


SWANKE HAYDEN CONNELL ARCHITECTS

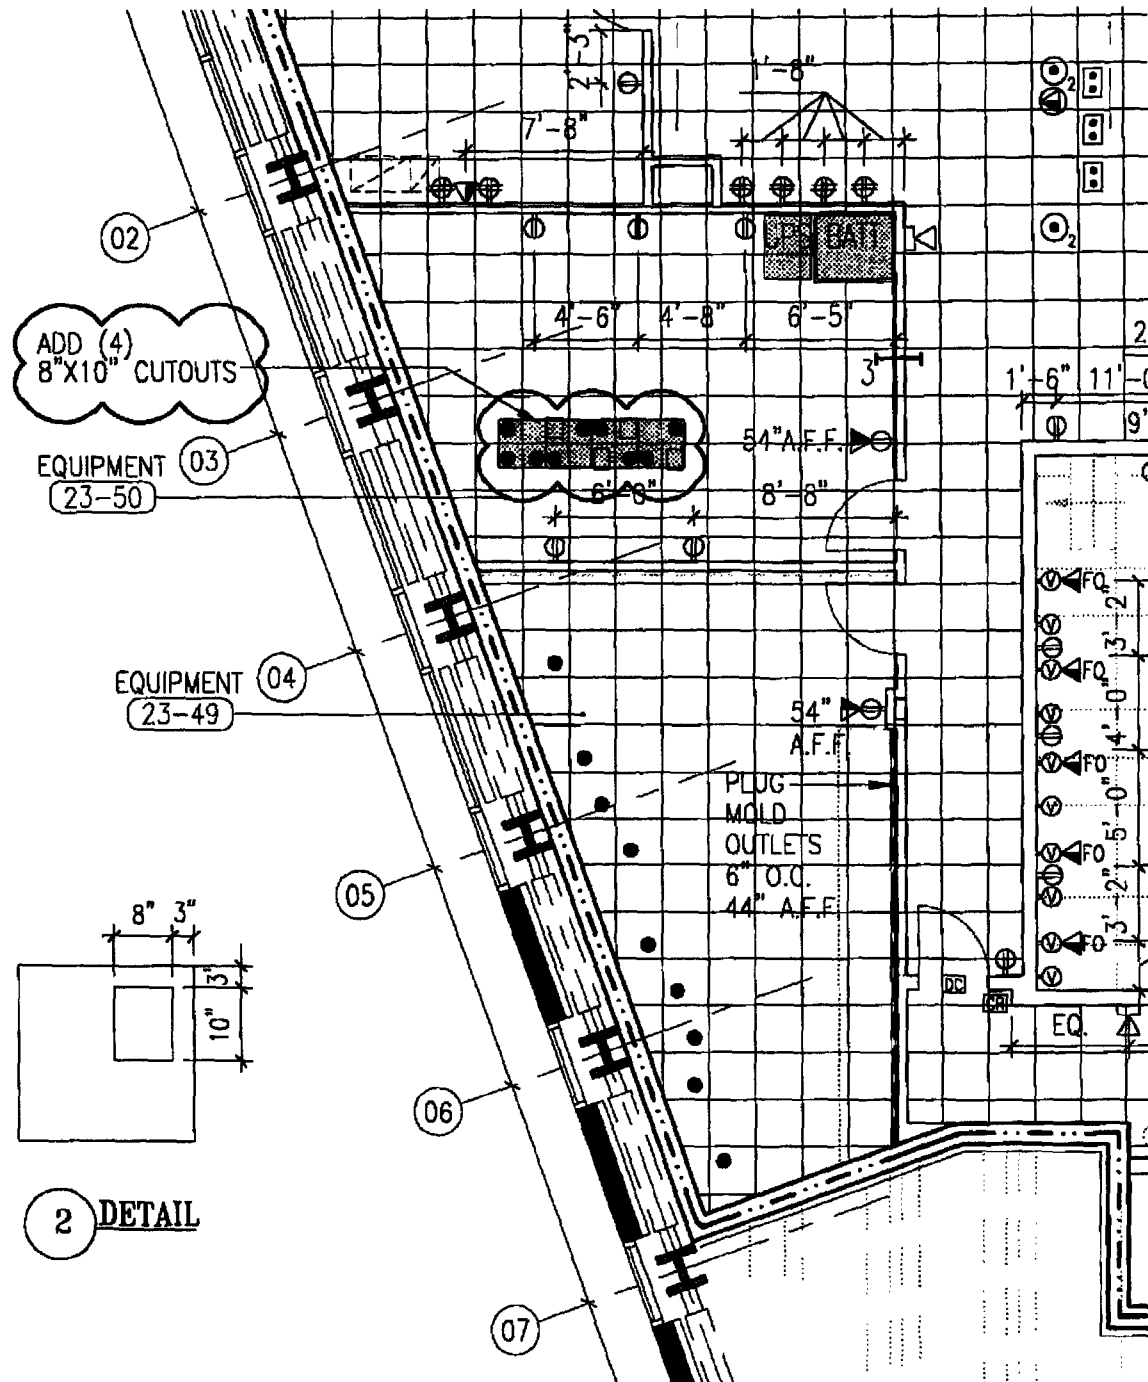

1 PART POWER PLAN RM# 23-50 & 23-49
1/8" = 1'-0"

No. Date Revisions

1 11/24/98 AS NOTED

Job Title/Drawing Title

MAYORS OFFICE OF EMERGENCY MANAGEMENT

Scale

1/8" = 1'-0"

Drawn By

FSK-43 R

Issued


Job No.

NOVEMBER 6, 1998 576A

© 1998 Swanke Hayden Connell Architects

Swanke Hayden Connell Ltd
285 Lafayette St., New York, New York 10012
212 226 8696, Fax 212 219 0059

SWANKE HAYDEN CONNELL ARCHITECTS

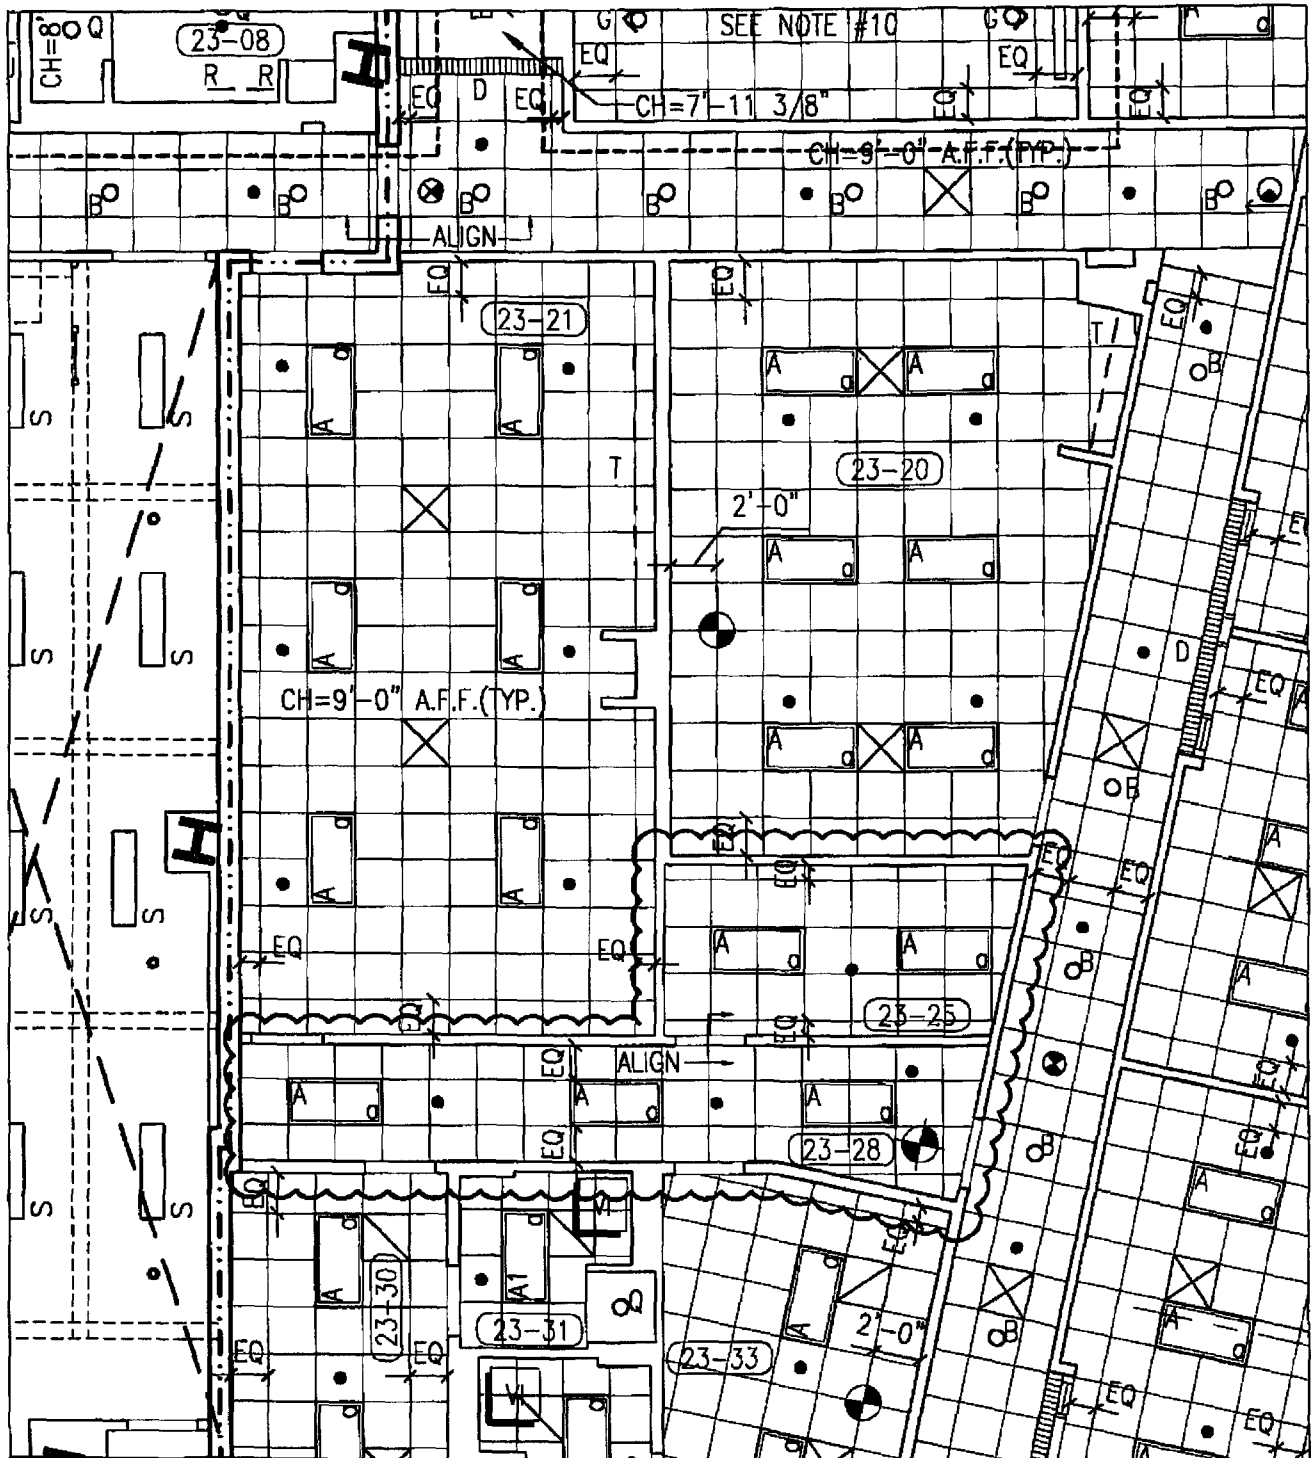

1 PART RCP
1/8" = 1'-0"

No. Date Revisions

1. 11/24/98 AS NOTED

Job Title/Drawing Title

MAYORS OFFICE OF EMERGENCY MANAGEMENT

PART REFLECTED CEILING PLAN

Scale

1/8" = 1'-0" FSK-38 R

Drawn By

JJC

Issued

10-30-98

Job No.

5576A

Swanke Hayden Connell Ltd
295 Lafayette St., New York, New York 10012
212 226 9696, Fax 212 219 0059

© 1995 Swanke Hayden Connell Architects

