


# SWANKE HAYDEN CONNELL ARCHITECTS

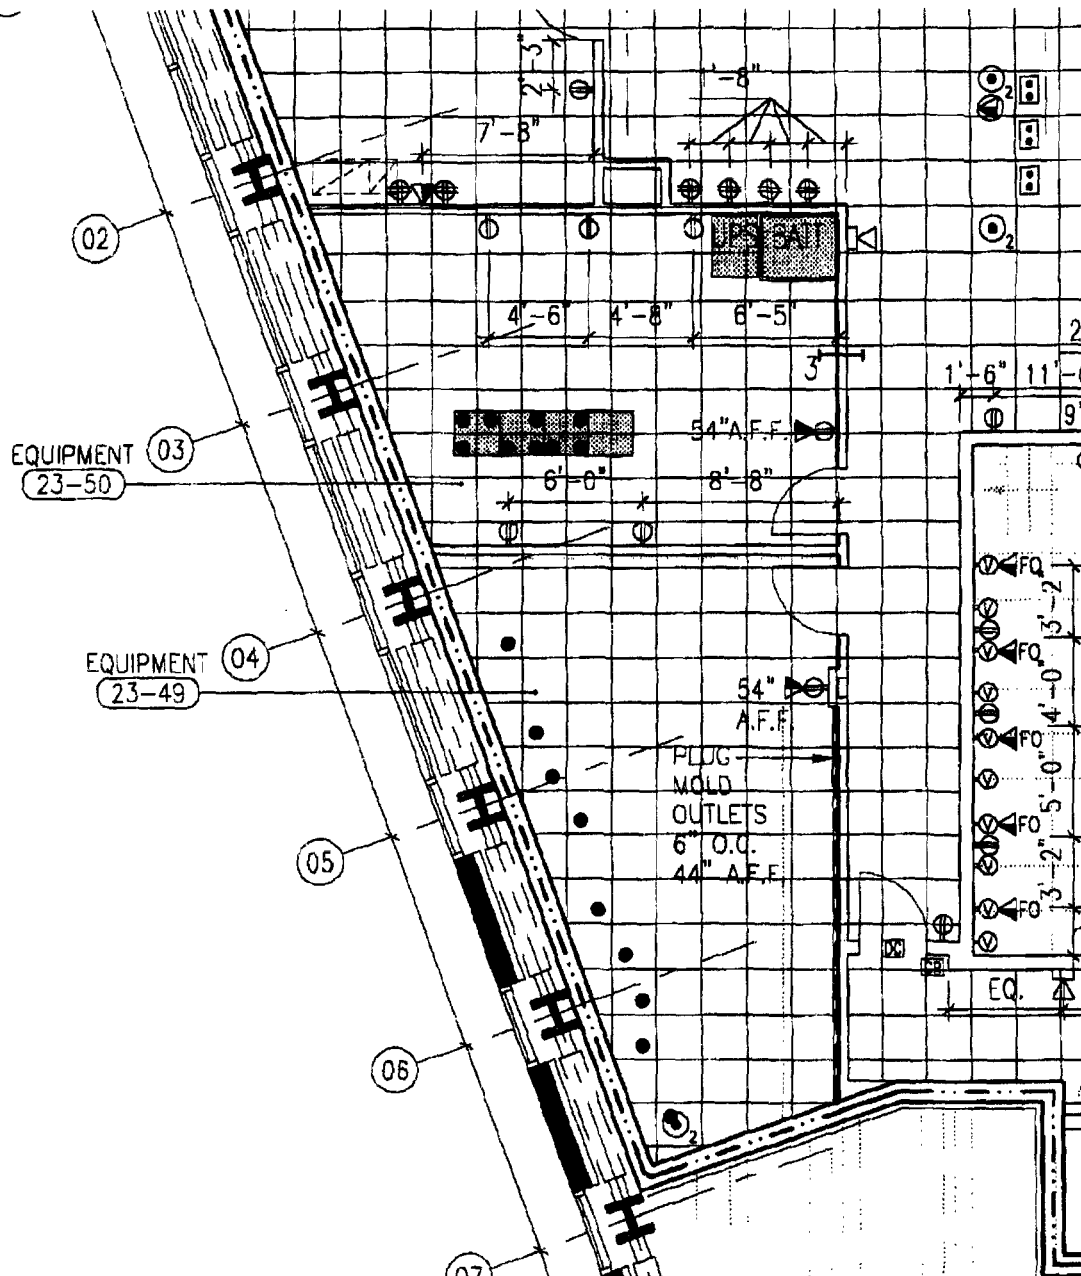

1 PART POWER PLAN RM# 23-50 & 23-49  
1/8" = 1'-0"

No. Date Revisions

Job Title/Drawing Title

MAYORS OFFICE OF EMERGENCY MANAGEMENT

Scale

1/8" = 1'-0"

Drawn By

FSK-43

Swanke Hayden Connell Ltd  
295 Lafayette St., New York, New York 10012  
212 226 9986, Fax 212 219 0069


Issued

Job No.


NOVEMBER 6, 1998 576A

© 1998 Swanke Hayden Connell Architects

**SWANKE HAYDEN CONNELL ARCHITECTS**

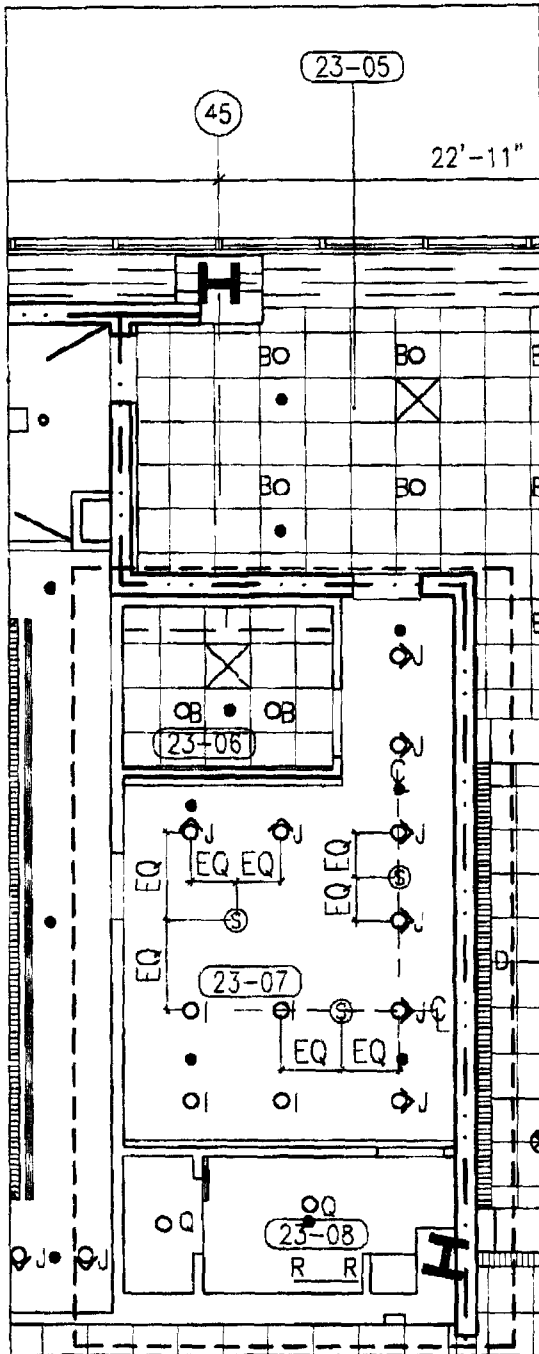

1 PART RCP RM# 23-07  
1/8" = 1'-0"

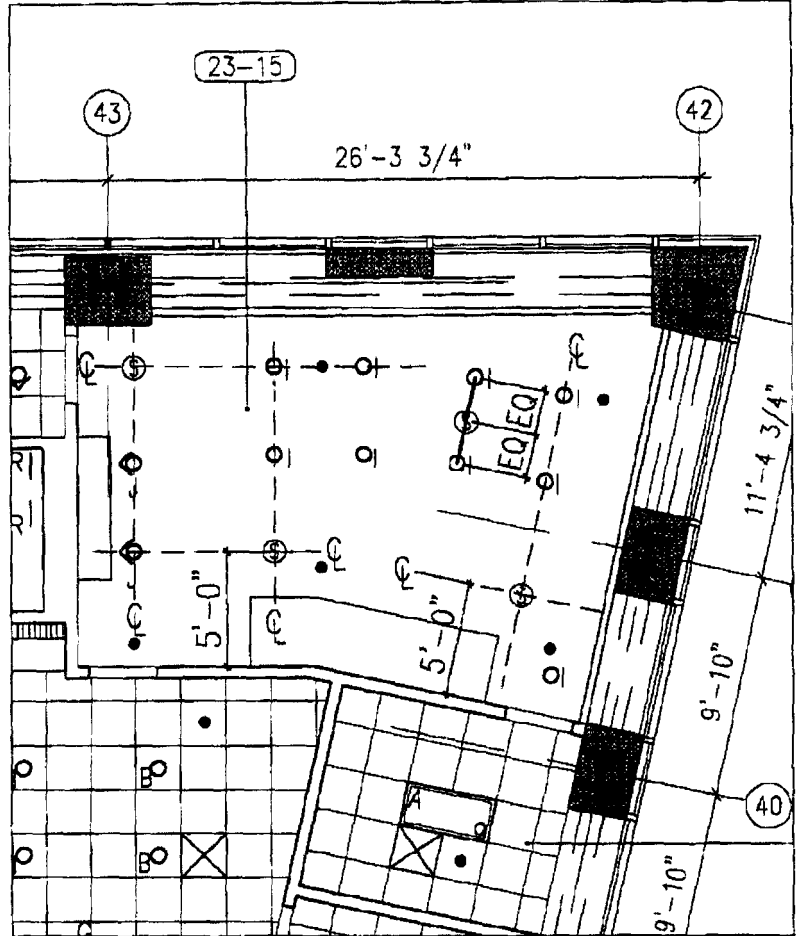

2 PART RCP RM# 23-15  
1/8" = 1'-0"

No. Date Revisions

Job Title/Drawing Title

Scale

MAYORS OFFICE OF EMERGENCY MANAGEMENT

1/8" = 1'-0"

SPEAKER LOCATION

Drawn By

FSK-45

Swanke Hayden Connell Ltd

Issued

Job No.

295 Lafayette St., New York, New York 10012

NOVEMBER 6, 1998

212 225 9696, Fax 212 219 0069

© 1998 Swanke Hayden Connell Architects



NYC-WTC 000167885