


SWANKE HAYDEN CONNELL ARCHITECTS

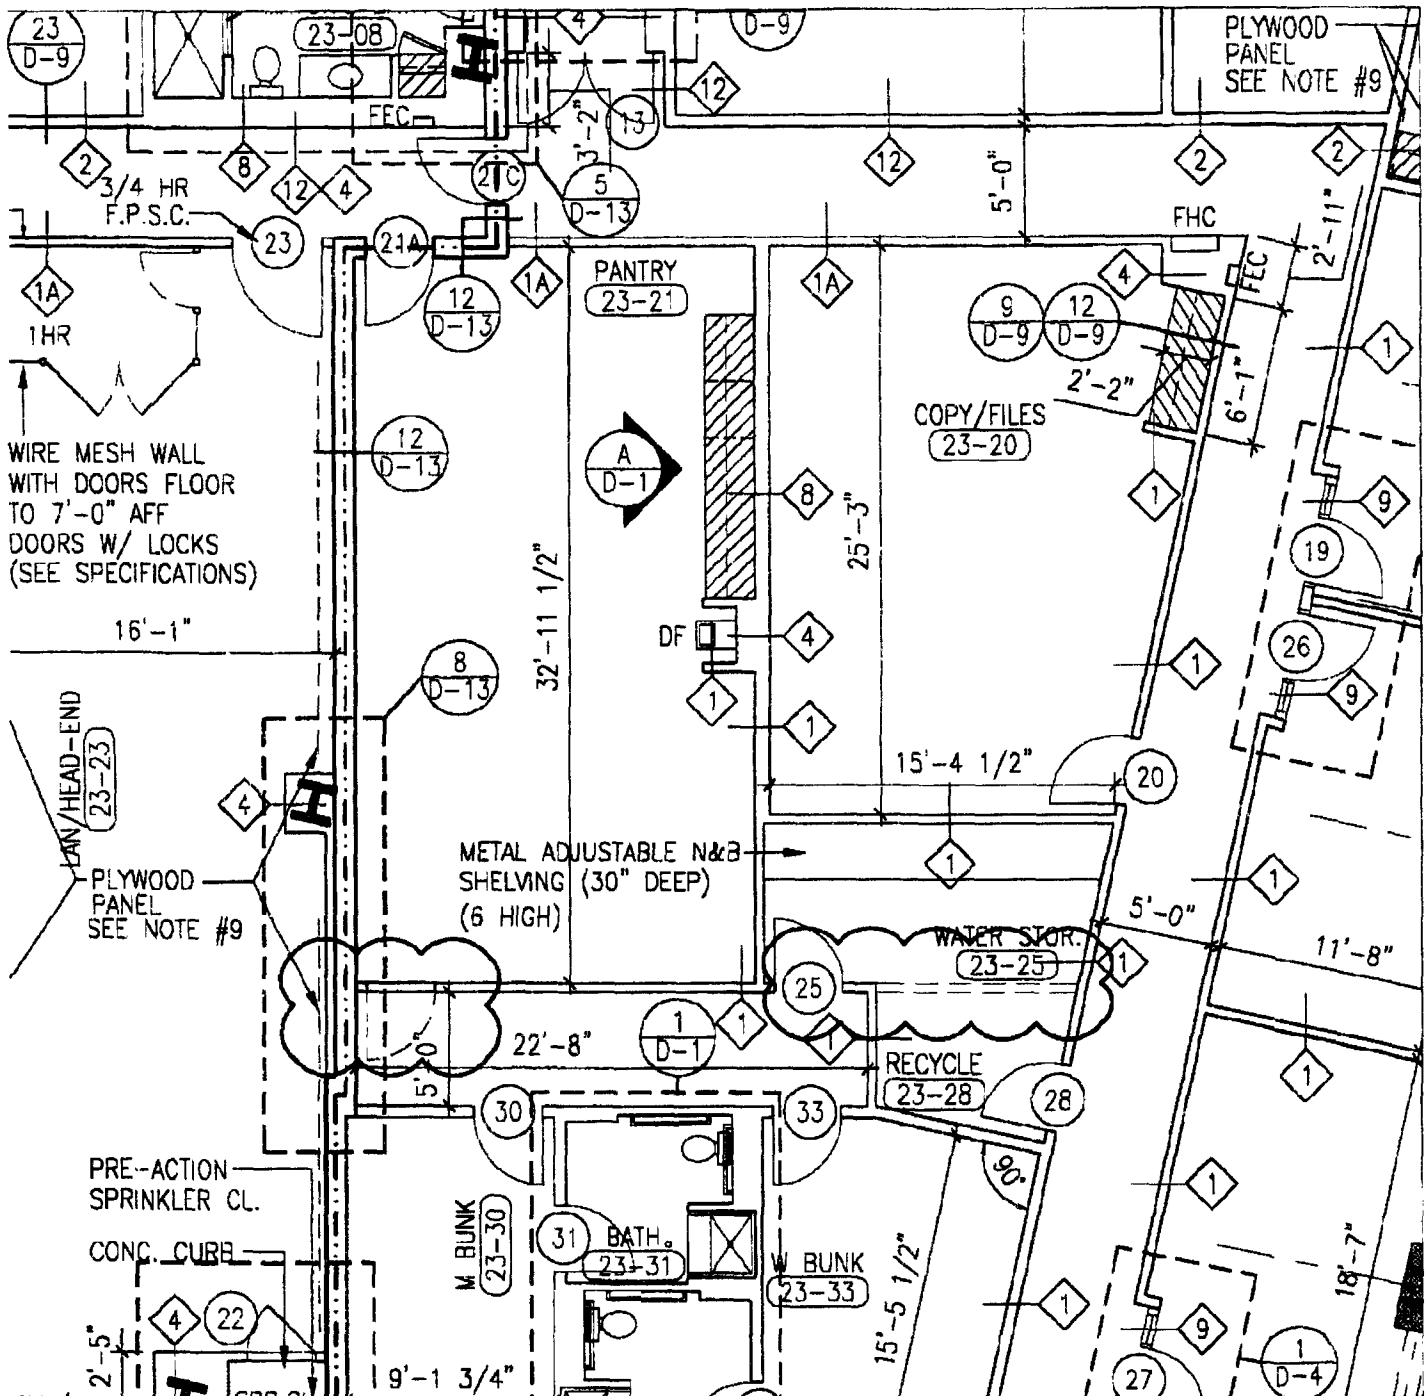

1 PART PLAN RECYCLE & WATER STOR.
1/8" = 1'-0"

No. Date Revisions

Job Title/Drawing Title

MAYORS OFFICE OF EMERGENCY MANAGEMENT

PART PARTITION PLAN

Swanke Hayden Connell Ltd

295 Lafayette St., New York, New York 10012

212 226 0086, Fax 212 219 0059

Scale

1/8" = 1'-0"

Drawn By

J.G.

Issued


10-30-98

Job No.

5576A

© 1998 Swanke Hayden Connell Architects

SWANKE HAYDEN CONNELL ARCHITECTS

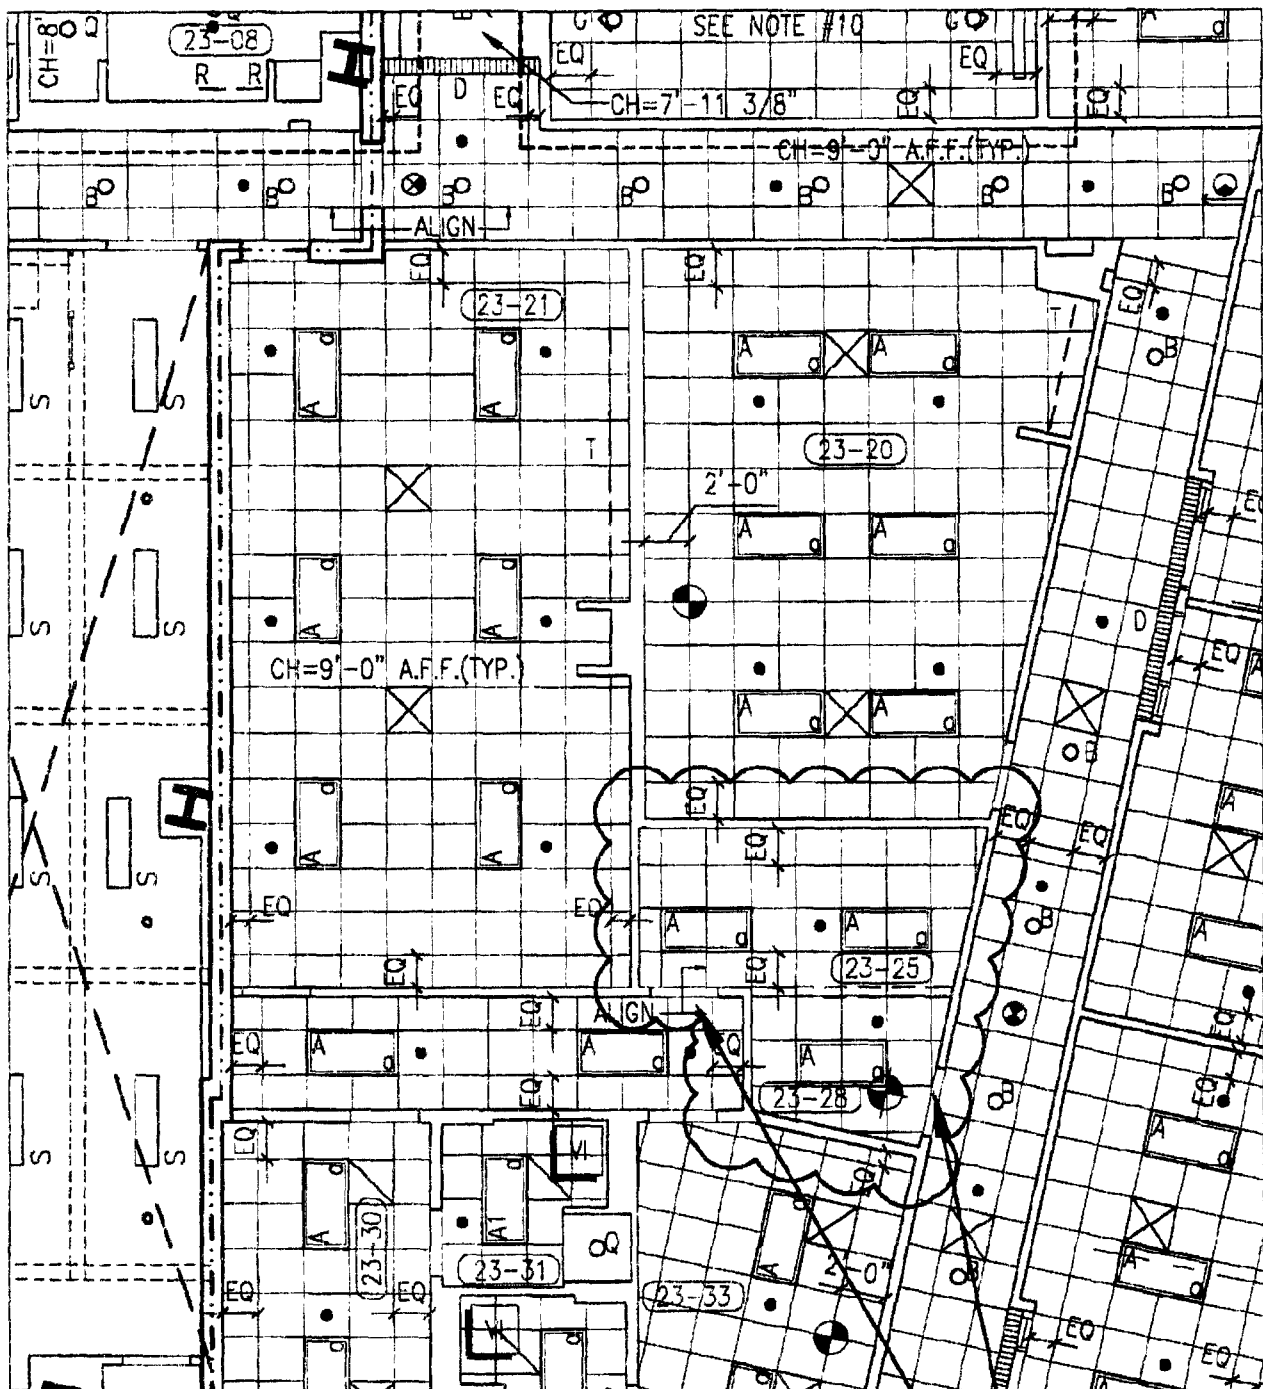

1 PART RCP
1/8" = 1'-0"

PROVIDE (2) WAY SWITCHES
AT BOTH DOORS

No. Date Revisions

Job Title/Drawing Title

MAYORS OFFICE OF EMERGENCY MANAGEMENT

PART REFLECTED CEILING PLAN

Swanke Hayden Connell Ltd

295 Lafayette St., New York, New York 10012

212 226 9698, Fax 212 219 0059

Scale

1/8" = 1'-0" **FSK-38**

Drawn By

JHG

Issued


10-30-98

Job No.

5576A

© 1995 Swanke Hayden Connell Architects

SWANKE HAYDEN CONNELL ARCHITECTS

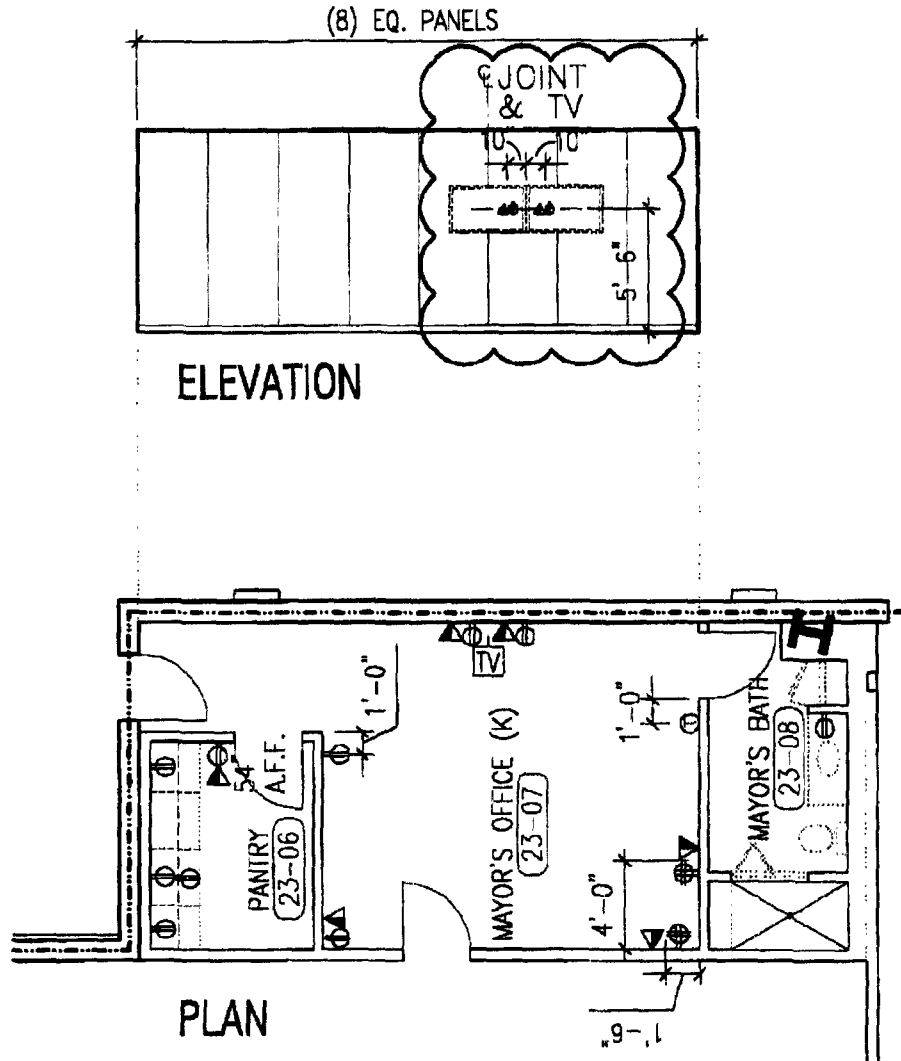

No. Date Revisions

1 11-2-98 AS NOTED

Job Title/Drawing Title

Mayor's Office of Emergency Management

Rm# 23-07, Outlet Location for Plasma T.V.'s

Scale

1/8" = 1'-0"

Drawn By

FSK-12

Issued

09/02/98

Job No.

5576A

Swanke Hayden Connell Ltd

295 Lafayette St., New York, New York 10012

212 226 9696, Fax 212 219 0059


© 1995 Swanke Hayden Connell Architects

Scale
1/4" = 1'-0" PSK-40
Drawn by


Issued
11/02/98
Job No. 5576A

© 1998, 1999, 2000, 2669, 2670


SWANKE HAYDEN CONNELL ARCHITECTS

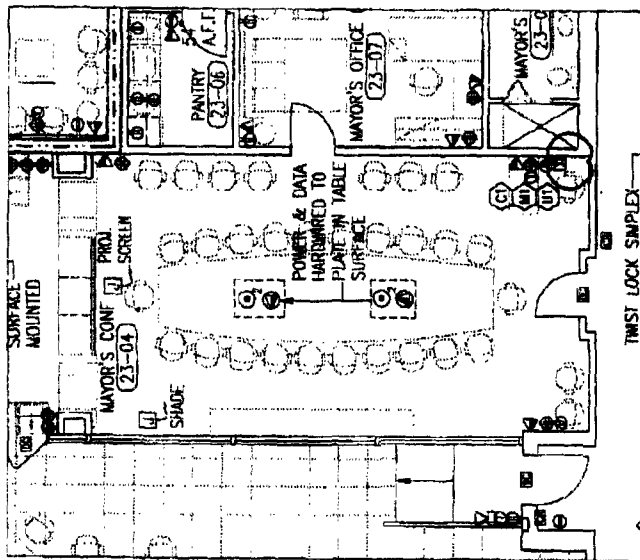

1 MAYORS CONF. ROOM
1/8" = 1'-0"

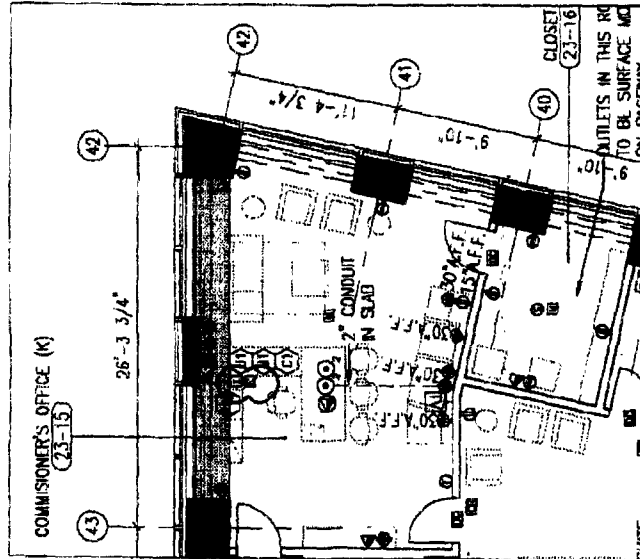

2 COMMISSIONER'S OFFICE
1/8" = 1'-0"

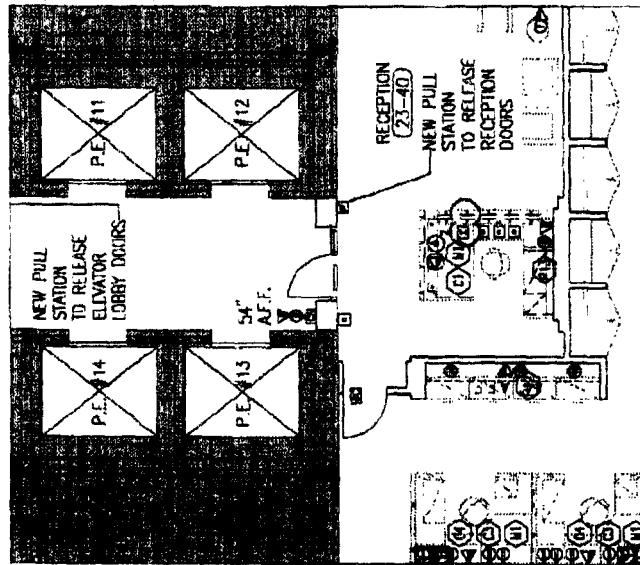

3 MAIN RECEPTION DESK
1/8" = 1'-0"

- INTERCOM SYSTEM
ELEVATOR "CALL BUTTON"

NOTES

- G.C. TO PROVIDE EQUIPMENT & ALL CABLEING OR POWER REQUIRED
- G.C. TO COORDINATE FINAL LOCATION OF DEVICES IN FIELD W/ ARCHITECT

11/02/98

405 Third Avenue, 11th

MAYORS OFFICE OF EMERGENCY MANAGEMENT

INTERCOM & CALL BUTTON LOCATION

Swanck Hayden Connell Ltd.
235 Lafayette St., New York, New York 10012
212 257 0000 Fax 212 237 0020

Scale

1/8" = 1'-0" PSK-39

Drawn By

Job No. 5576A

10/30/98

© 1998 Swanck Hayden Connell Architects