


SWANKE HAYDEN CONNELL ARCHITECTS

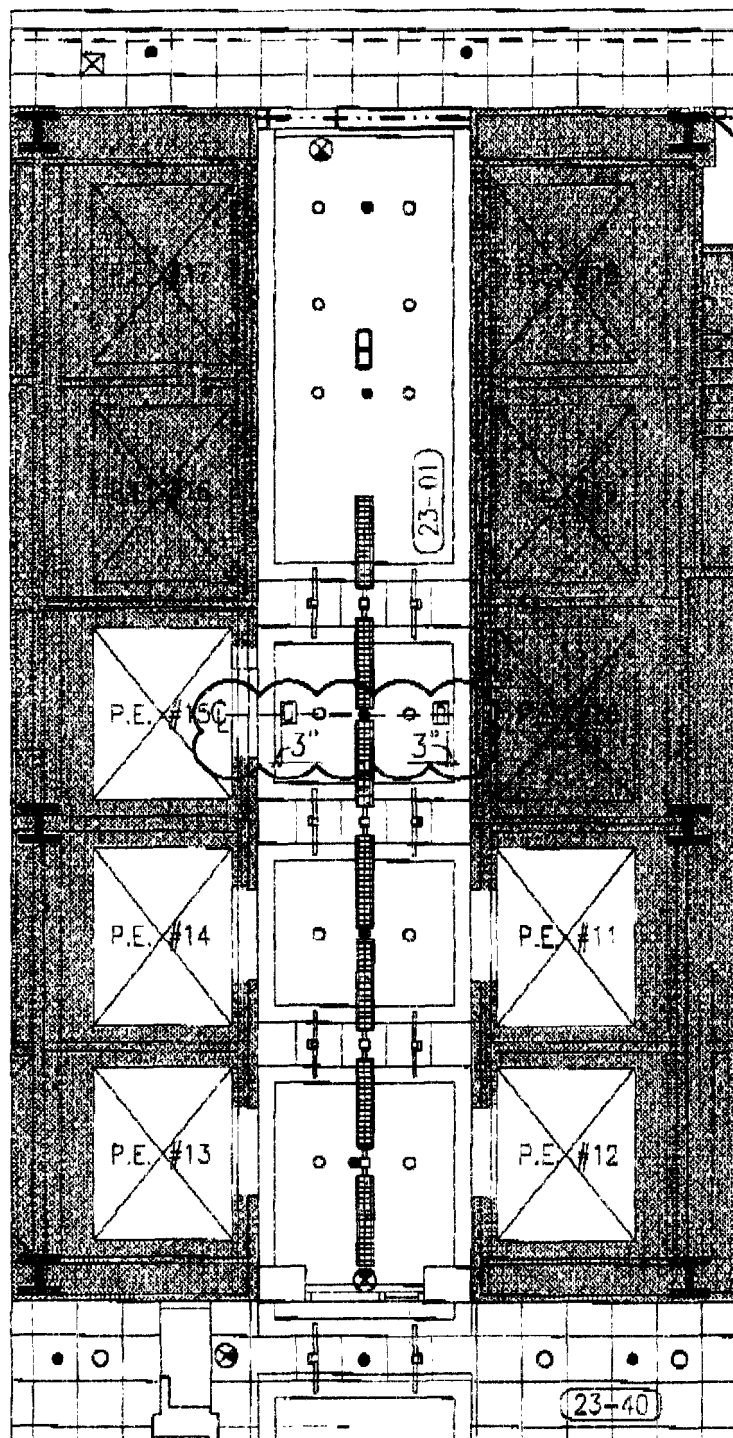

1 PART RCP PLAN
1/8"=1'-0"

No. Date Revisions

Job Title/Drawing Title

**MAYORS OFFICE OF EMERGENCY MANAGEMENT
ELEVATOR LOBBY V. CAM LOCATION**

Scale

1/8"=1'-0"

FSK-32

Drawn By

JJC

Job No.


10-21-98

5576A


Swanke Hayden Connell Ltd
295 Lafayette St., New York, New York 10012
212 226 9696, Fax 212 219 0059

© 1996 Swanke Hayden Connell Architects

SWANKE HAYDEN CONNELL ARCHITECTS

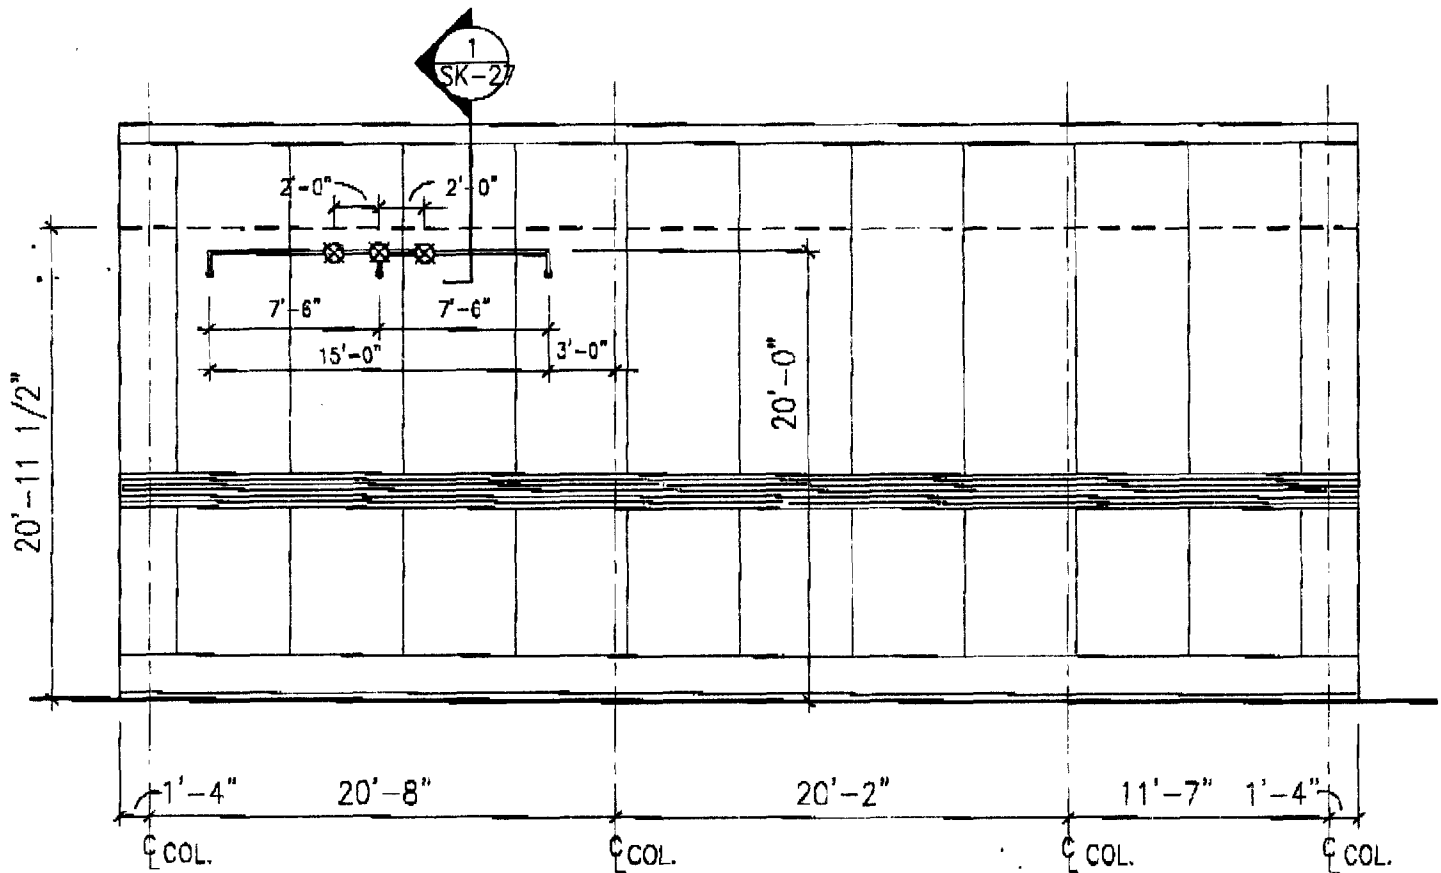


A NORTH ELEVATION @ PENTHOUSE
1/8"=1'-0"

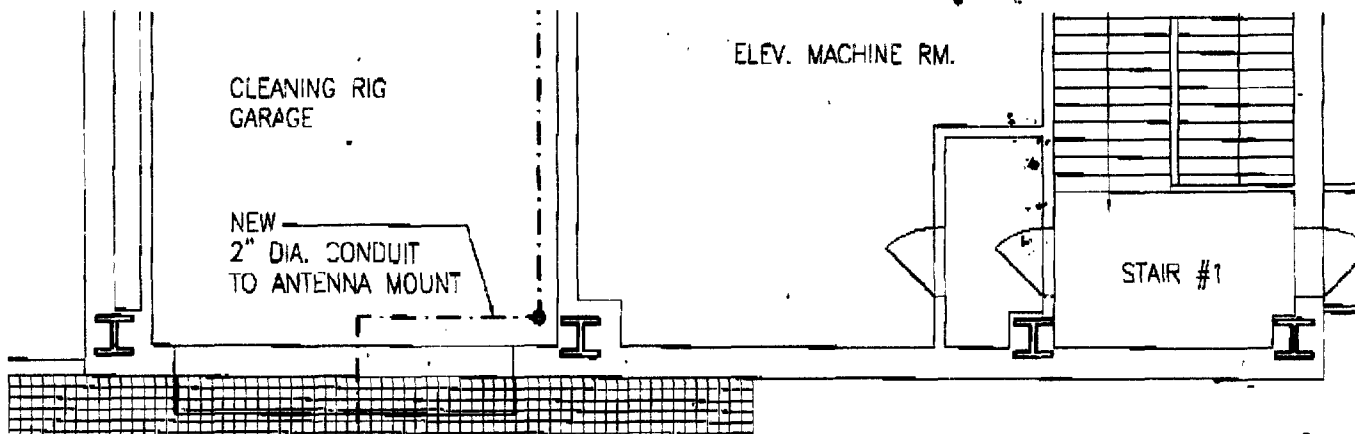

1 KEY PLAN FOR ROOF
1/8"=1'-0"

No. Date Revisions	Job Title/Drawing Title	Scale	
	MAYORS OFFICE OF EMERGENCY MANAGEMENT	1/8"=1'-0"	FSK-26
		Drawn By	
		Issued	Job No.
		10.08.98	5576A
	Swanke Hayden Connell Ltd 296 Lafayette St., New York, New York 10012 212 226 9096, Fax 212 219 0059	© 1995 Swanke Hayden Connell Architects	

SWANKE HAYDEN CONNELL ARCHITECTS

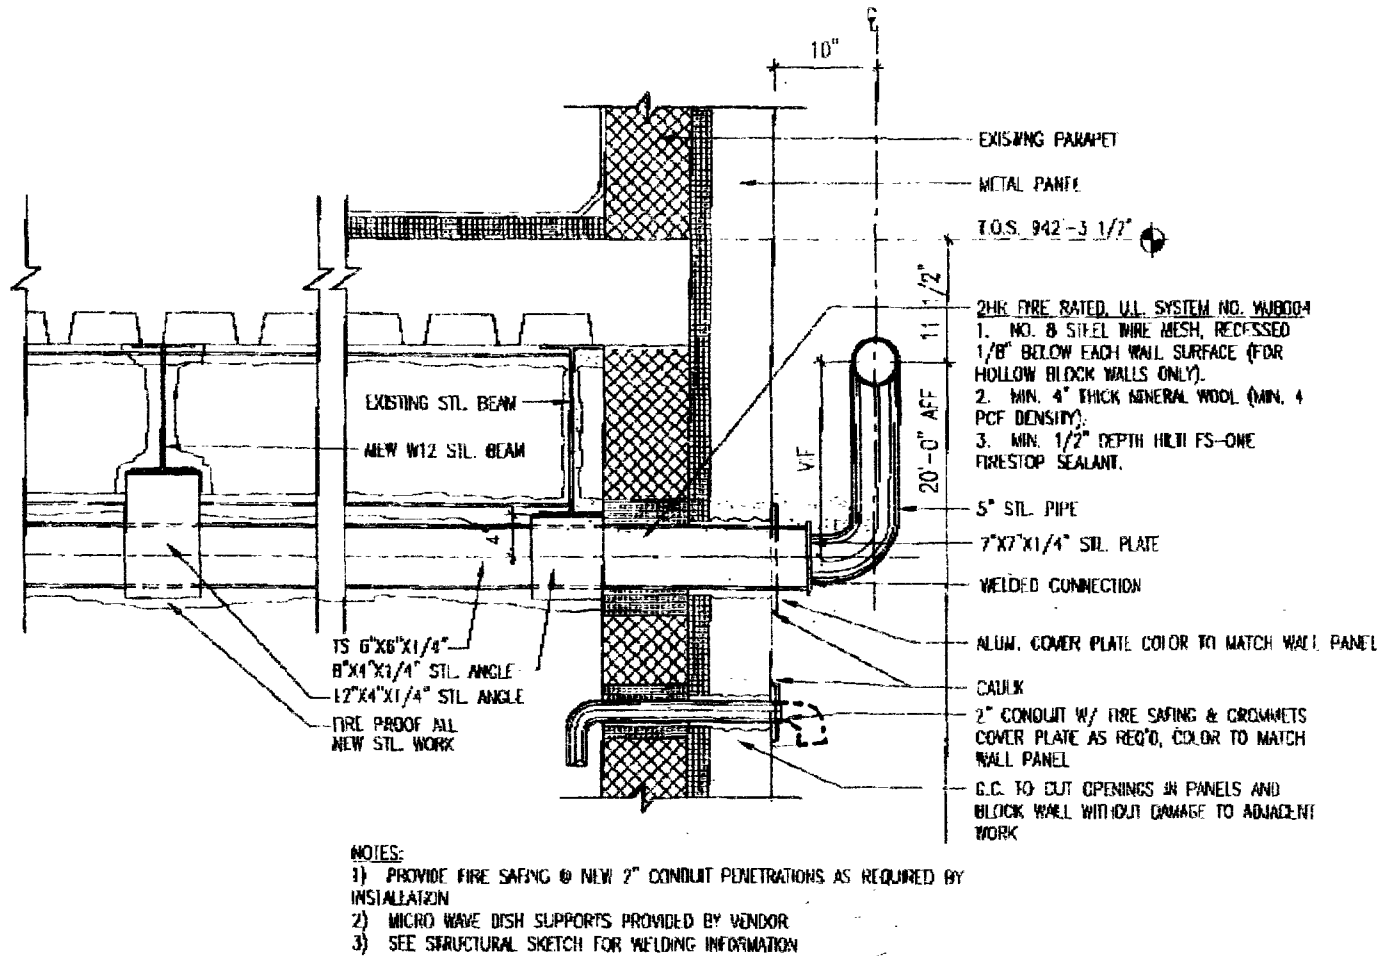

No. Date Revision

Job Title/Drawing Title

MAYORS OFFICE OF EMERGENCY MANAGEMENT

PIPE WALL SUPPORT @ DISHES

Swanke Hayden Connell 340
 230 Lafayette St., New York, New York 10012
 212 226 8804, Fax 212 819 0089

Scale

N.E.S.
Drawn By

FSK-27

Issued

10/21/98

Job No.

5526A

© 1998 Swanke Hayden Connell Architects

10/22/98 08:35 FAX 2122180258


SWANKE HAYDEN CONNELL

004/005


10/22/98 08:36 FAX 2122190258
SENT BY:

SWANKE HAYDEN CONNELL
10-20-98 11:16AM CANTOR SEINUK GROUP

005/005
2190059/# 2/ 2

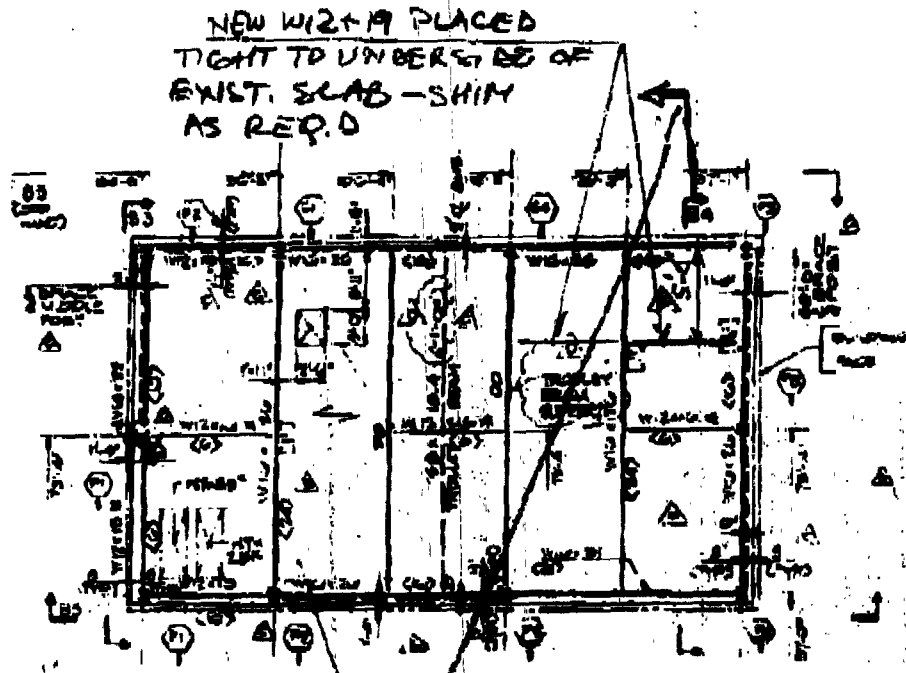

ROOF BULKHEAD FRAMING PLAN

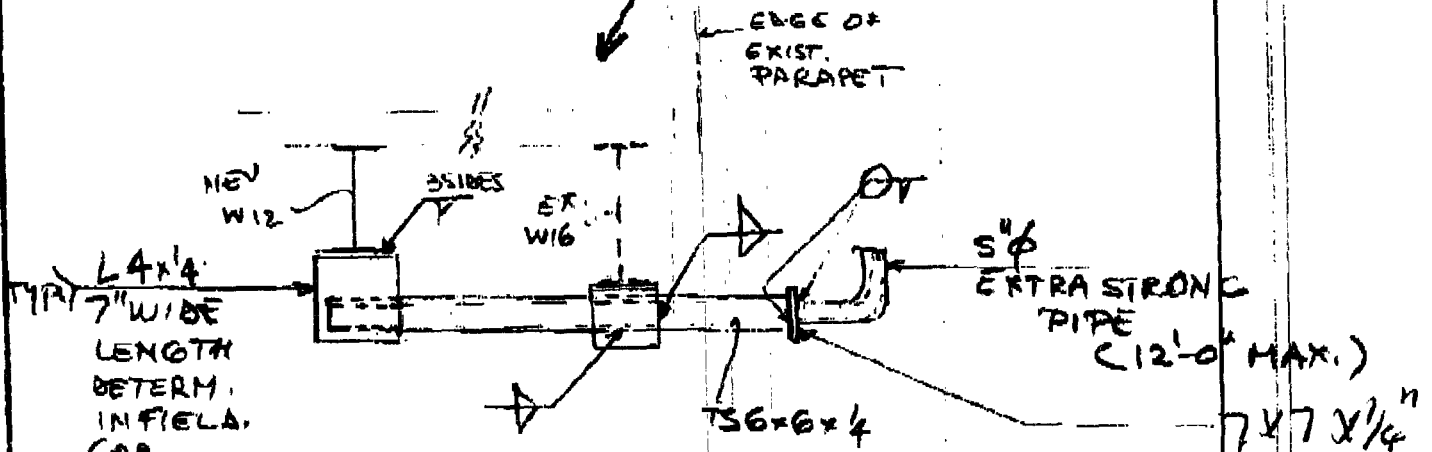

CANTOR SEINUK GROUP, PC
CONSULTING ENGINEERS
600 MADISON AVENUE
NEW YORK, NEW YORK 10022



STRUCTURE

DEM

SUBJECT

ROOF - ANTENNA SUPPORT

ARCHITECT

SHCA

DATE

10/20/98

SK.

S-R.A.