


BARCLAY STREET

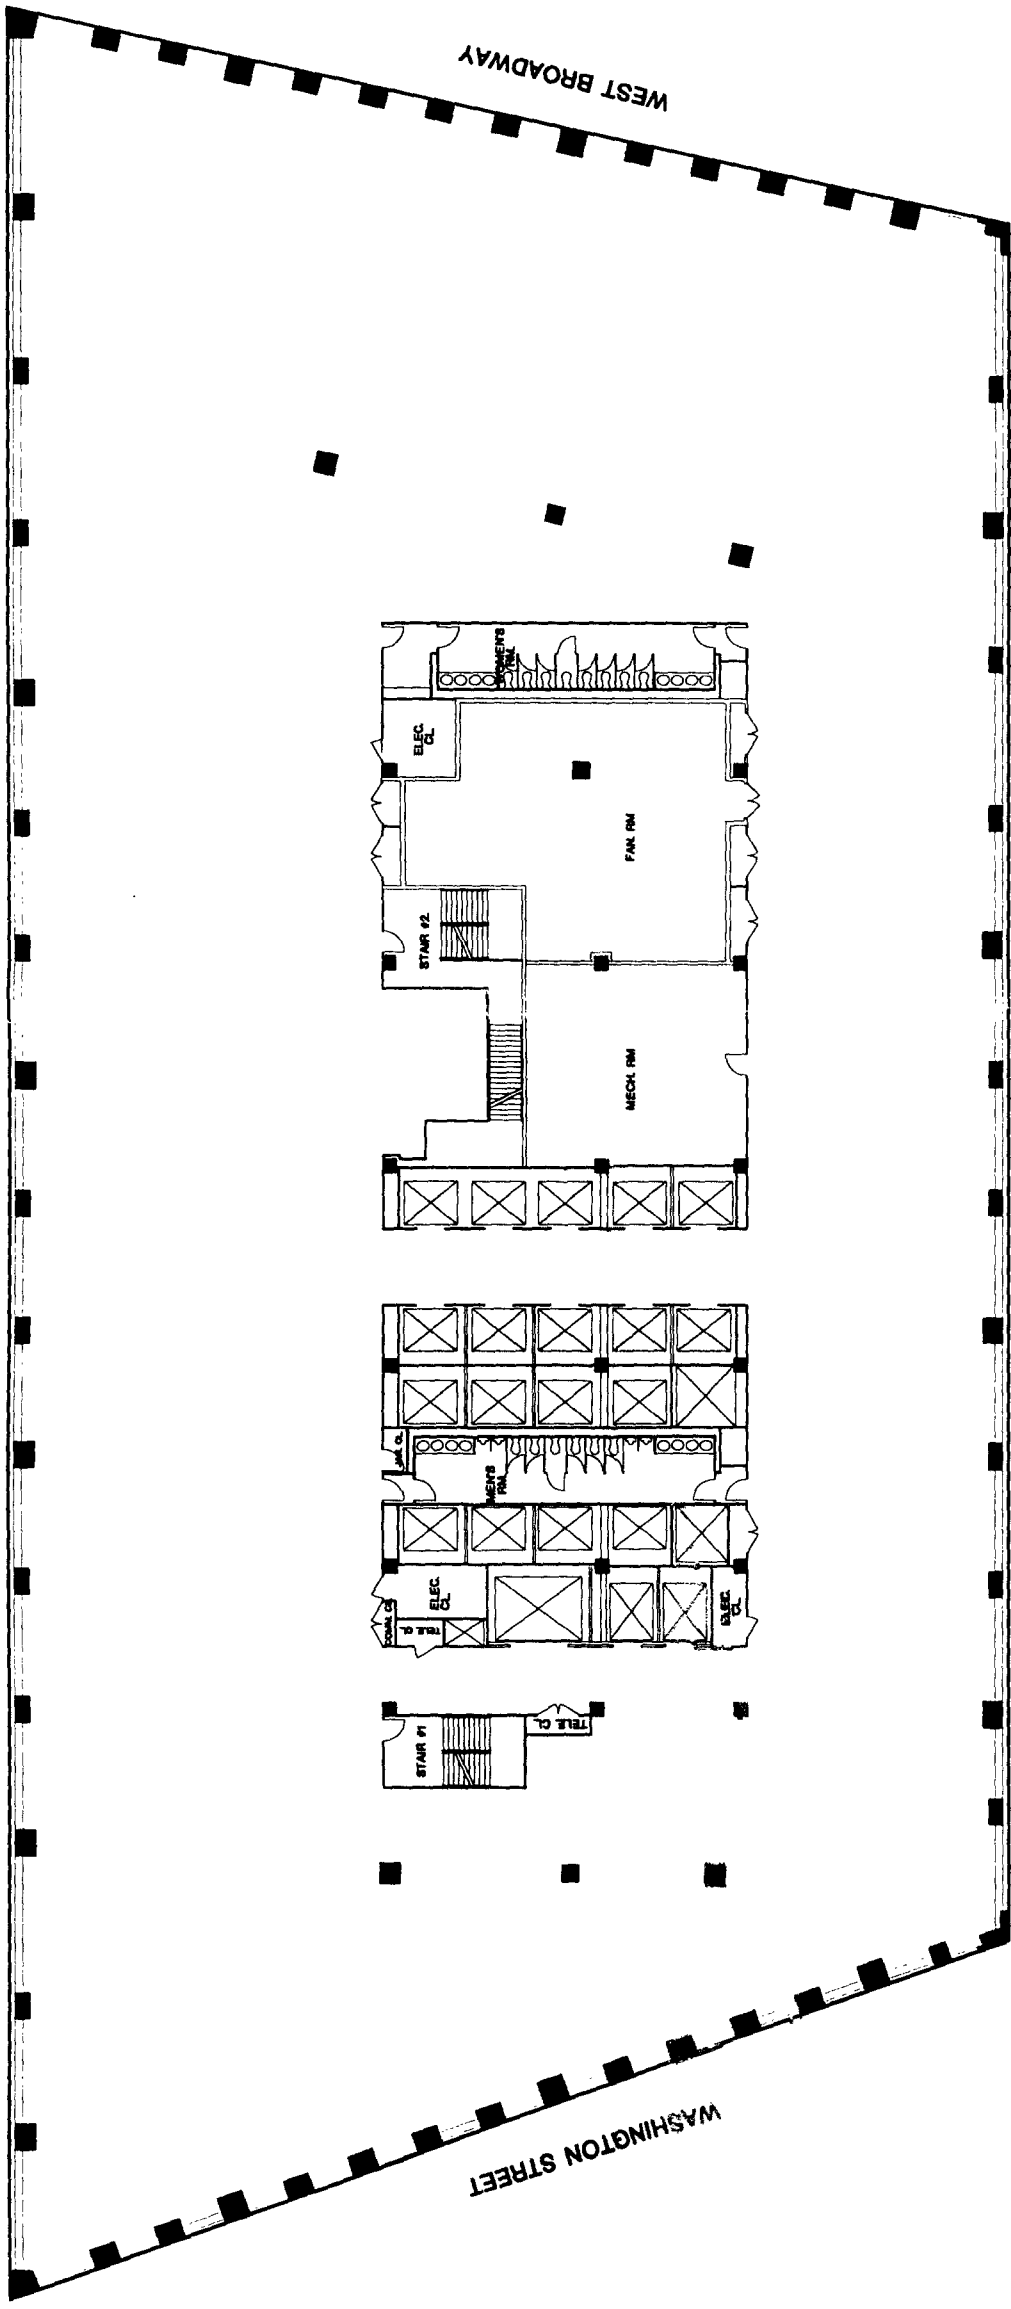

WASHINGTON STREET

WEST BROADWAY

SITE PLAN

Project Name: MAYOR'S OFFICE OF EMERGENCY MGMT.

NYC Project Number: 96-1346

7 WORLD TRADE CENTER

NEW YORK, NY

Block: -


Lot: -

Zone District: - C6-4

Zone Map: 12b

Date 7-14-97

 SCALE 1/8"=1'-0"



IA Jefferson

INTERIOR

ARCHITECTS

P.C.

305 EAST 47th STREET
3RD FLOOR
NEW YORK, NY 10017
212 688 2080 FAX 212 733 8472

23RD FLOOR PLAN