

NOV 17 '98 16:07 FR AMBASSADOR CONSTR. C0212 949 9762 TO 6694107
11/03/1998 18:19 15167521309

P.26/36

PAGE 01

AIRFLEX INDUSTRIAL, INC.

965 Conklin Street • East Farmingdale, NY 11735 • Tel: (516) 752-1219 • Fax: (516) 752-1309

November 3, 1998

Ambassador Construction Corp.
317 Madison Avenue
New York, NY 10019

Attn.: M. Schneider

Re: Mayor's OEM
7 World Trade Center
Airflex Job No. A215

Dear Martin:

Per your request, the cost to cut three holes in the metal siding of the existing penthouse to accommodate the 6" x 6" structural tubes by others will be \$1,540.

All layout of hole locations, chopping of existing parapet and sealing of openings is not included.

Sincerely,


Airflex Industrial




Frank Paolillo
Project Manager

cc: JF, A TB

SWANKE HAYDEN CONNELL ARCHITECTS

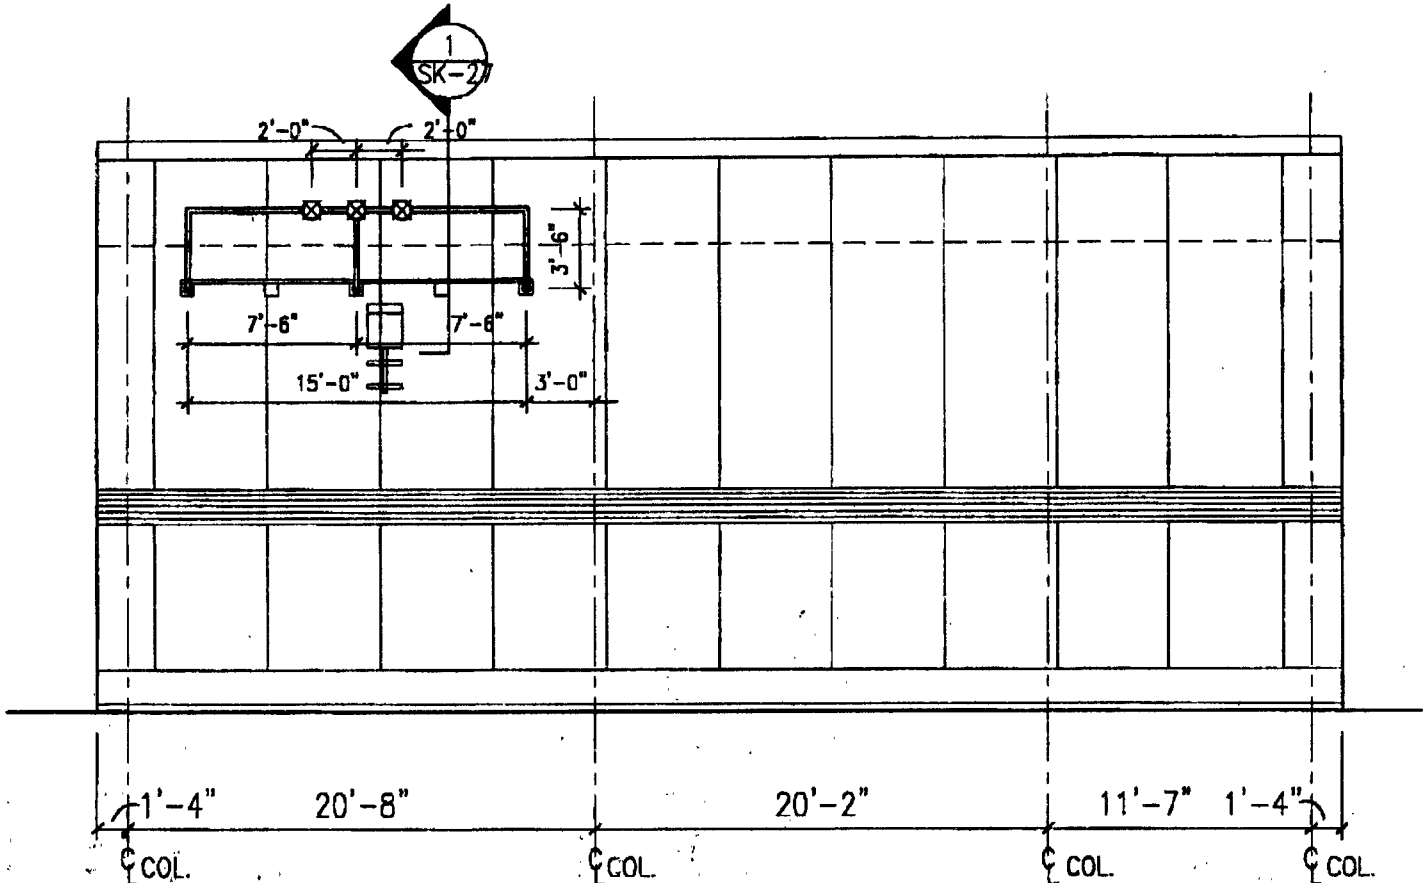


A NORTH ELEVATION @ PENTHOUSE
1/8"=1'-0"

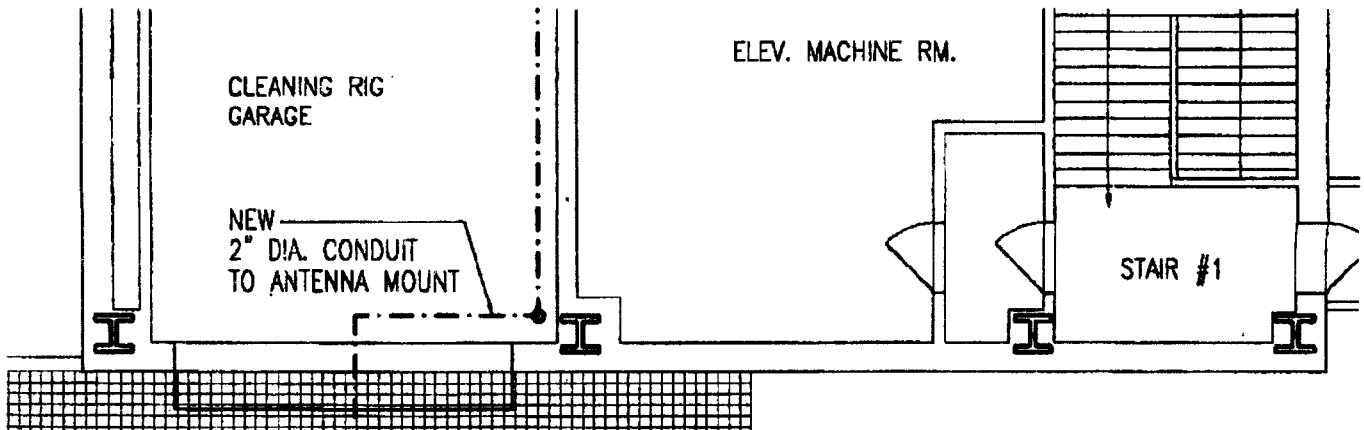

1 KEY PLAN FOR ROOF
1/8"=1'-0"

No.	Date	Revisions	Job Title/Drawing Title	Scale
1.	11/9/98	REV. NORTH ELEV. MAYORS OFFICE OF EMERGENCY MANAGEMENT	NORTH ELEV. @ PENTHOUSE	1/8"=1'-0"
				Drawn By FSK-26
				Issued 10.08.98
				Job No. 5576A
				© 1995 Swanke Hayden Connell Architects

STATE BAR COUNCIL

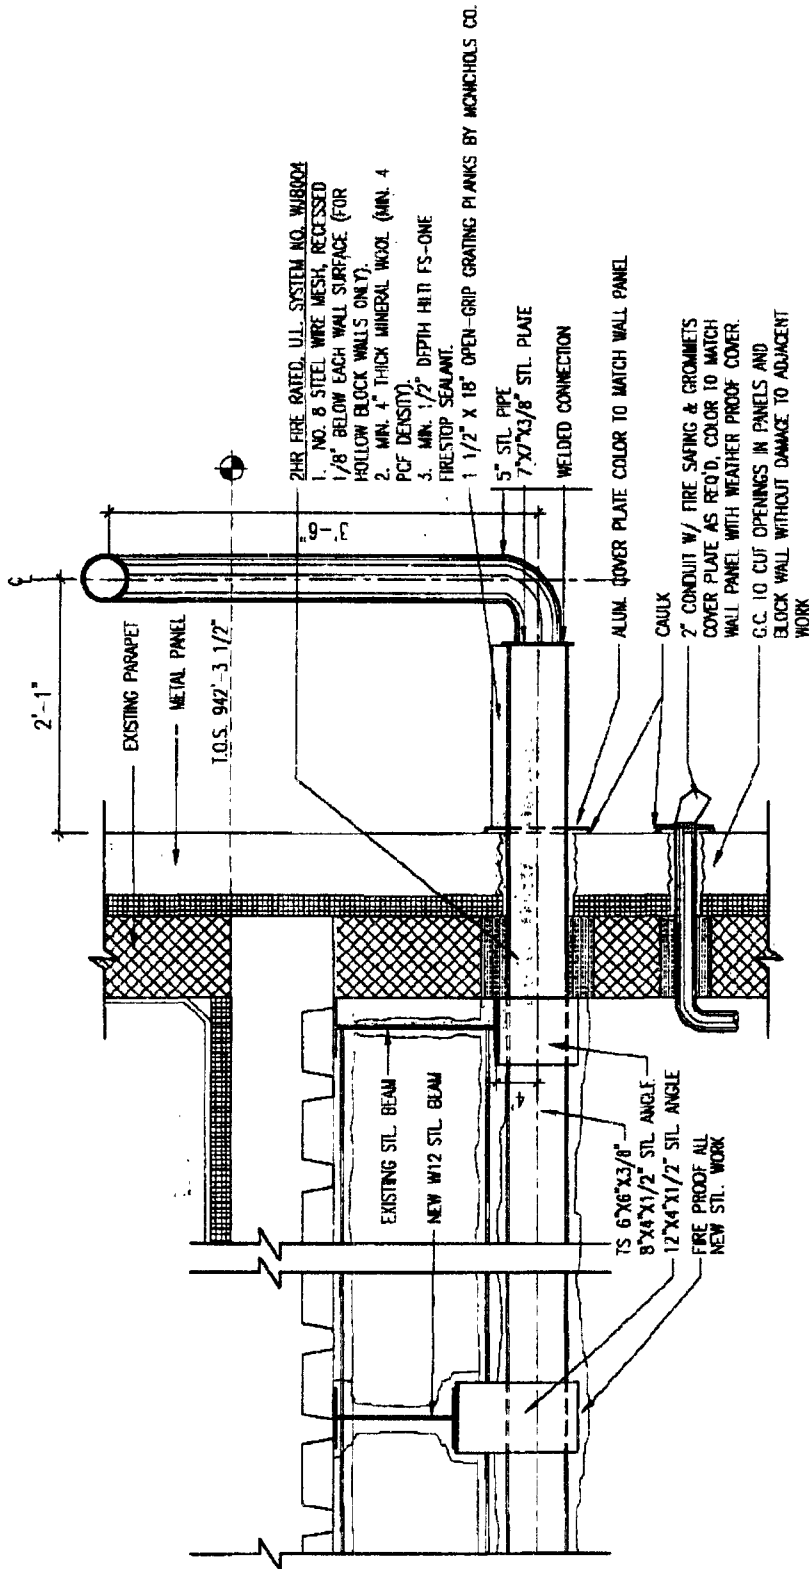

- NOTES:
- 1) PROVIDE FIRE SAFING @ NEW 2" CONDUIT PENETRATIONS AS REQUIRED BY INSTALLATION
 - 2) MICRO WAVE DISH SUPPORTS PROVIDED BY VENDOR
 - 3) SEE STRUCTURAL SKETCH FOR WELDING INFORMATION
 - 4) G.C. TO COORDINATE 6"x6" STEEL TUBE SUPPORT WITH EXISTING LIGHT FIXTURE.


No.	Date Revision	Description
1	11/9/98	ADDED GRATING & RAISED PIPE

Job title/working title
MAYORS OFFICE OF EMERGENCY MANAGEMENT
PIPE HALL SUPPORT @ DISHS


Stanley Hayden Connell Ltd.
395 Lafayette St., New York, New York 10012
212 268 9894, Fax 212 219 0459

Scale
N.I.S.
Drawn By
FSK-27
Issued
10/21/98
Job No. 5576A
© 1998 Bentley Systems, Incorporated

NEW W12+19 PLACED
TIGHT TO UNDERBOS OF
EXIST. SLAB - SHIM
AS REQ'D

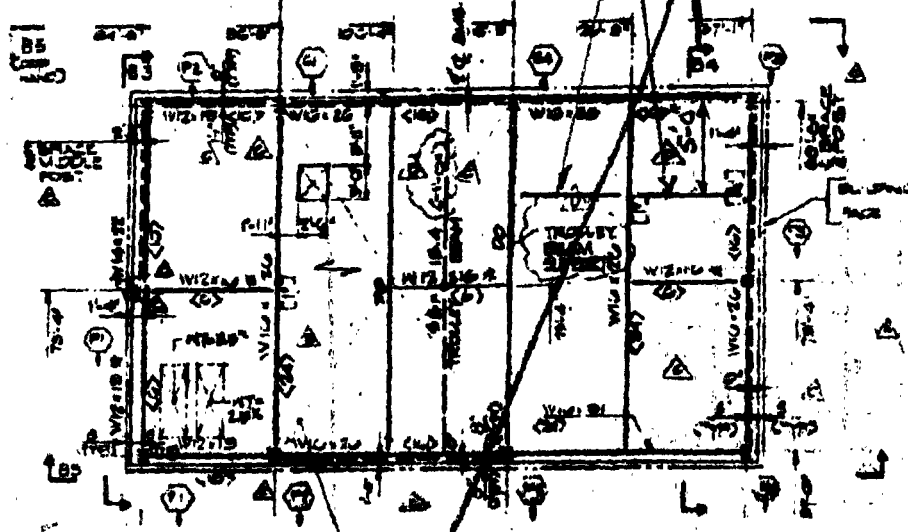

ROOF BULKHEAD FRAMING PLAN

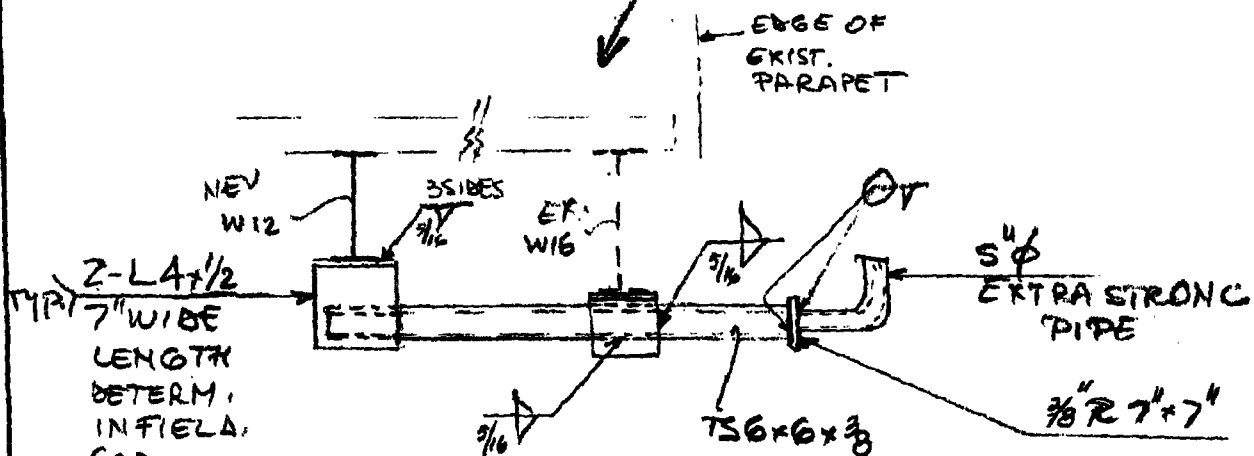

CANTOR SEINUK GROUP, PC CONSULTING ENGINEERS 800 MADISON AVENUE NEW YORK, NEW YORK 10022 CS	STRUCTURE OEM 7 W T C	
	SUBJECT ROOF - ANTENNA SUPPORT	
	ARCHITECT SHC A	
	DATE 10/20/98	SK. S-R.A.