



SWANKE HAYDEN CONNELL ARCHITECTS

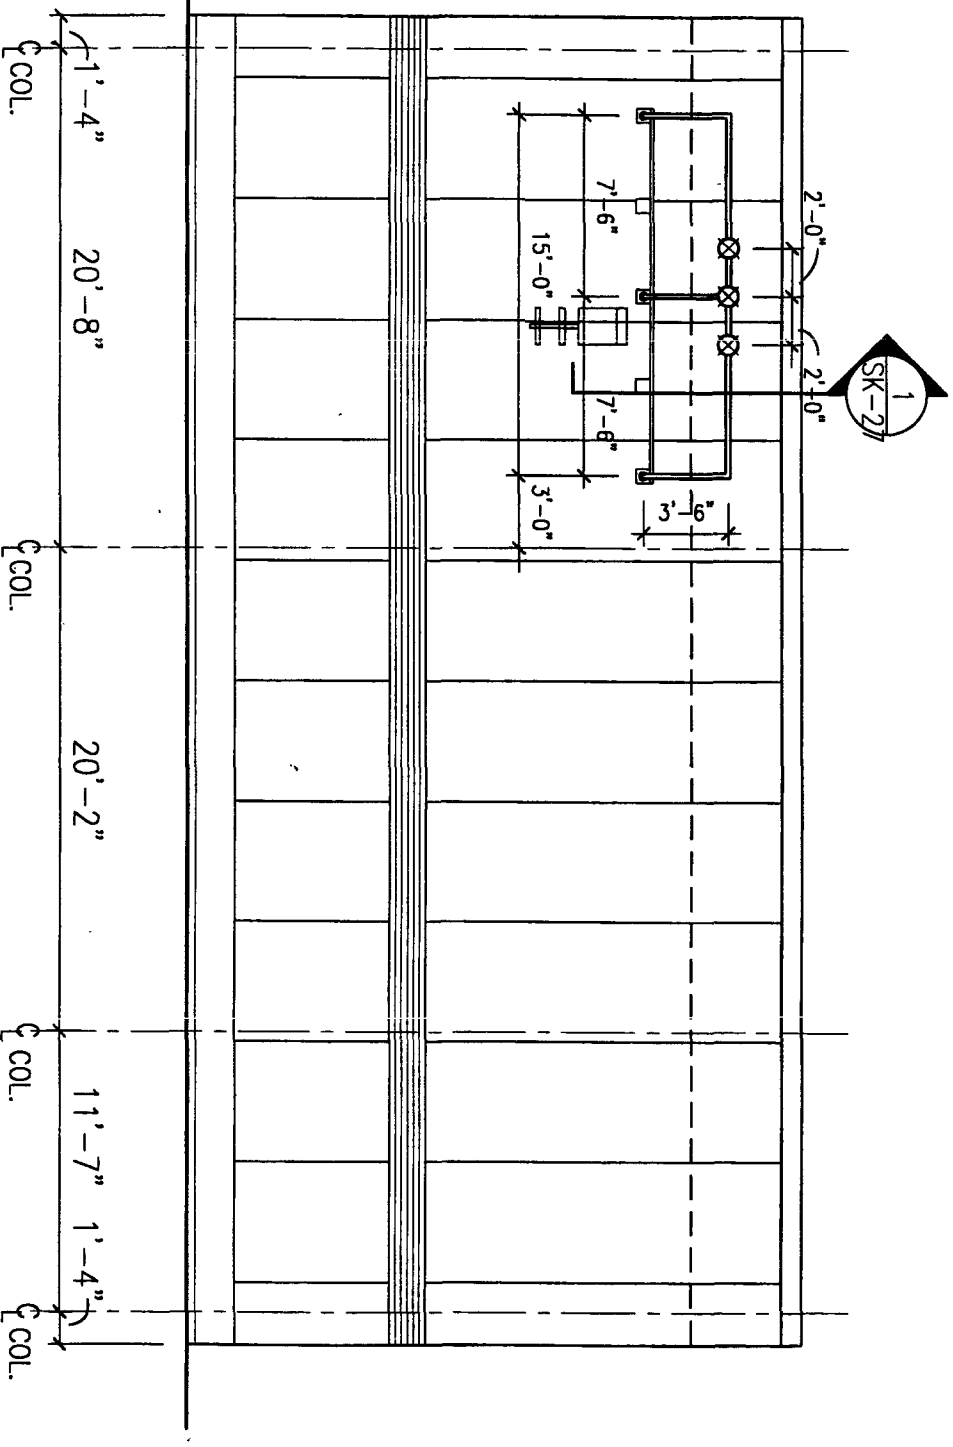

A
NORTH ELEVATION @ PENTHOUSE
1/8"=1'-0"

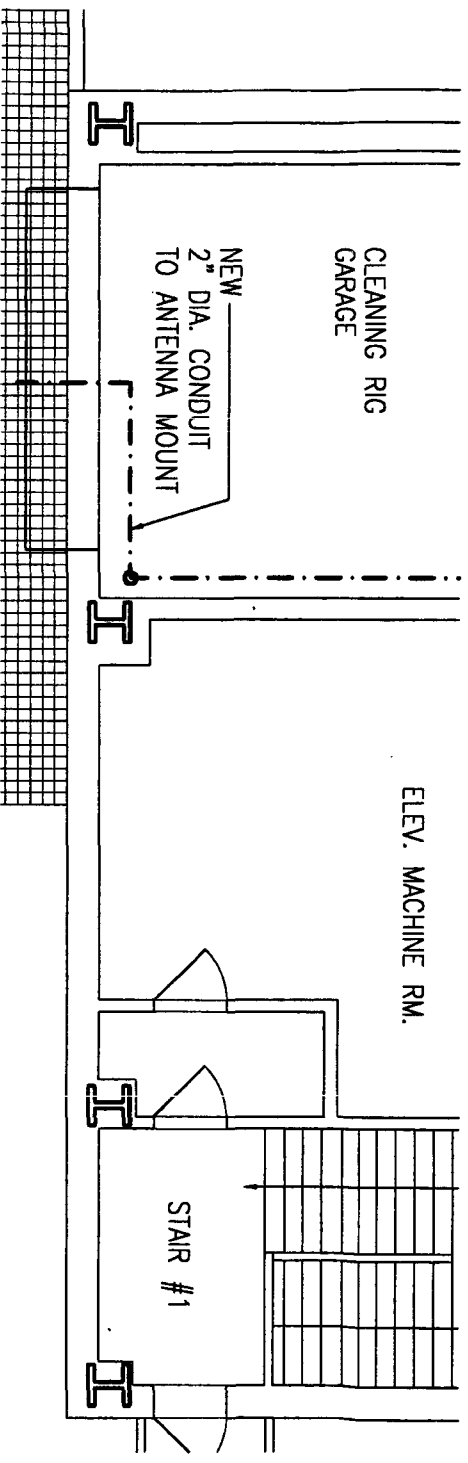

1
KEY PLAN FOR ROOF
1/8"=1'-0"

No. Date Revisions

Job Title/Drawing Title

Scale

1. 11/9/98 REV. NORTH ELEV. MAYORS OFFICE OF EMERGENCY MANAGEMENT

1/8"=1'-0"

FSK-26

NORTH ELEV. @ PENTHOUSE


Job No.

5576A

Swanke Hayden Connell Ltd
285 Lafayette St., New York, New York 10012
212 226 9686, Fax 212 219 0069


Issued
10.08.98

© 1995 Swanke Hayden Connell Architects

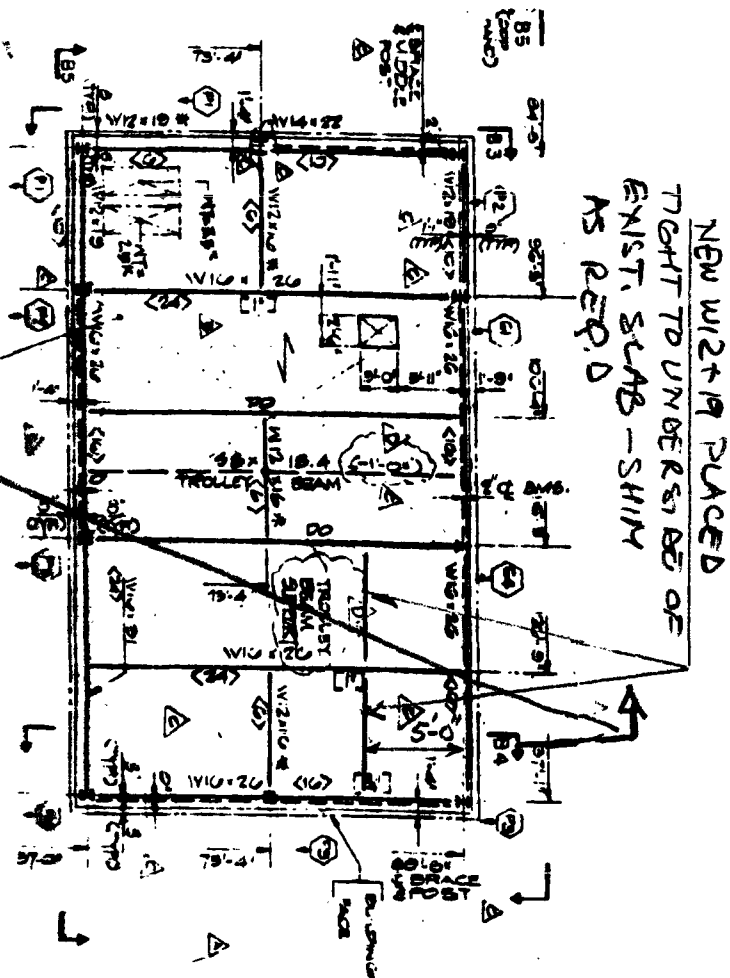

ROOF BULKHEAD FRAMING PLAN

EDGE OF EXIST. PARAPET

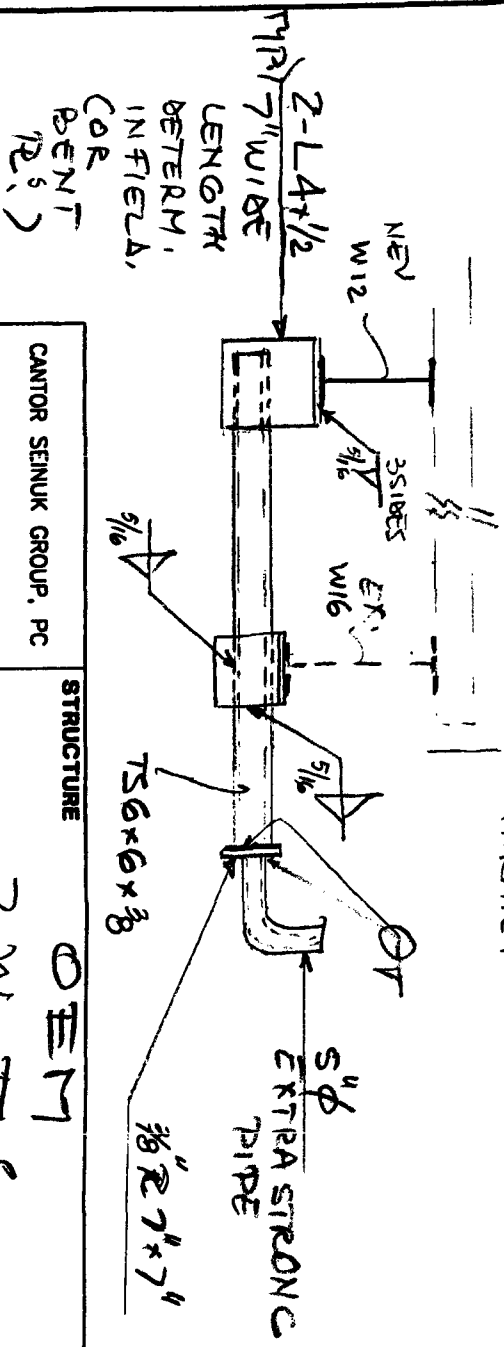

2-L 4x1/2
7\"/>

756x6x3/8
3/8\"/>

EXTRA STRONG
PIPE

CANTOR SEINUK GROUP, PC
CONSULTING ENGINEERS
600 MADISON AVENUE
NEW YORK, NEW YORK 10022



STRUCTURE

OEM

SUBJECT

ROOF - ANTENNA SUPPORT

ARCHITECT

SHC A


DATE

10/20/98

SK.

S-R.A.

SWANKE HAYDEN CONNELL ARCHITECTS

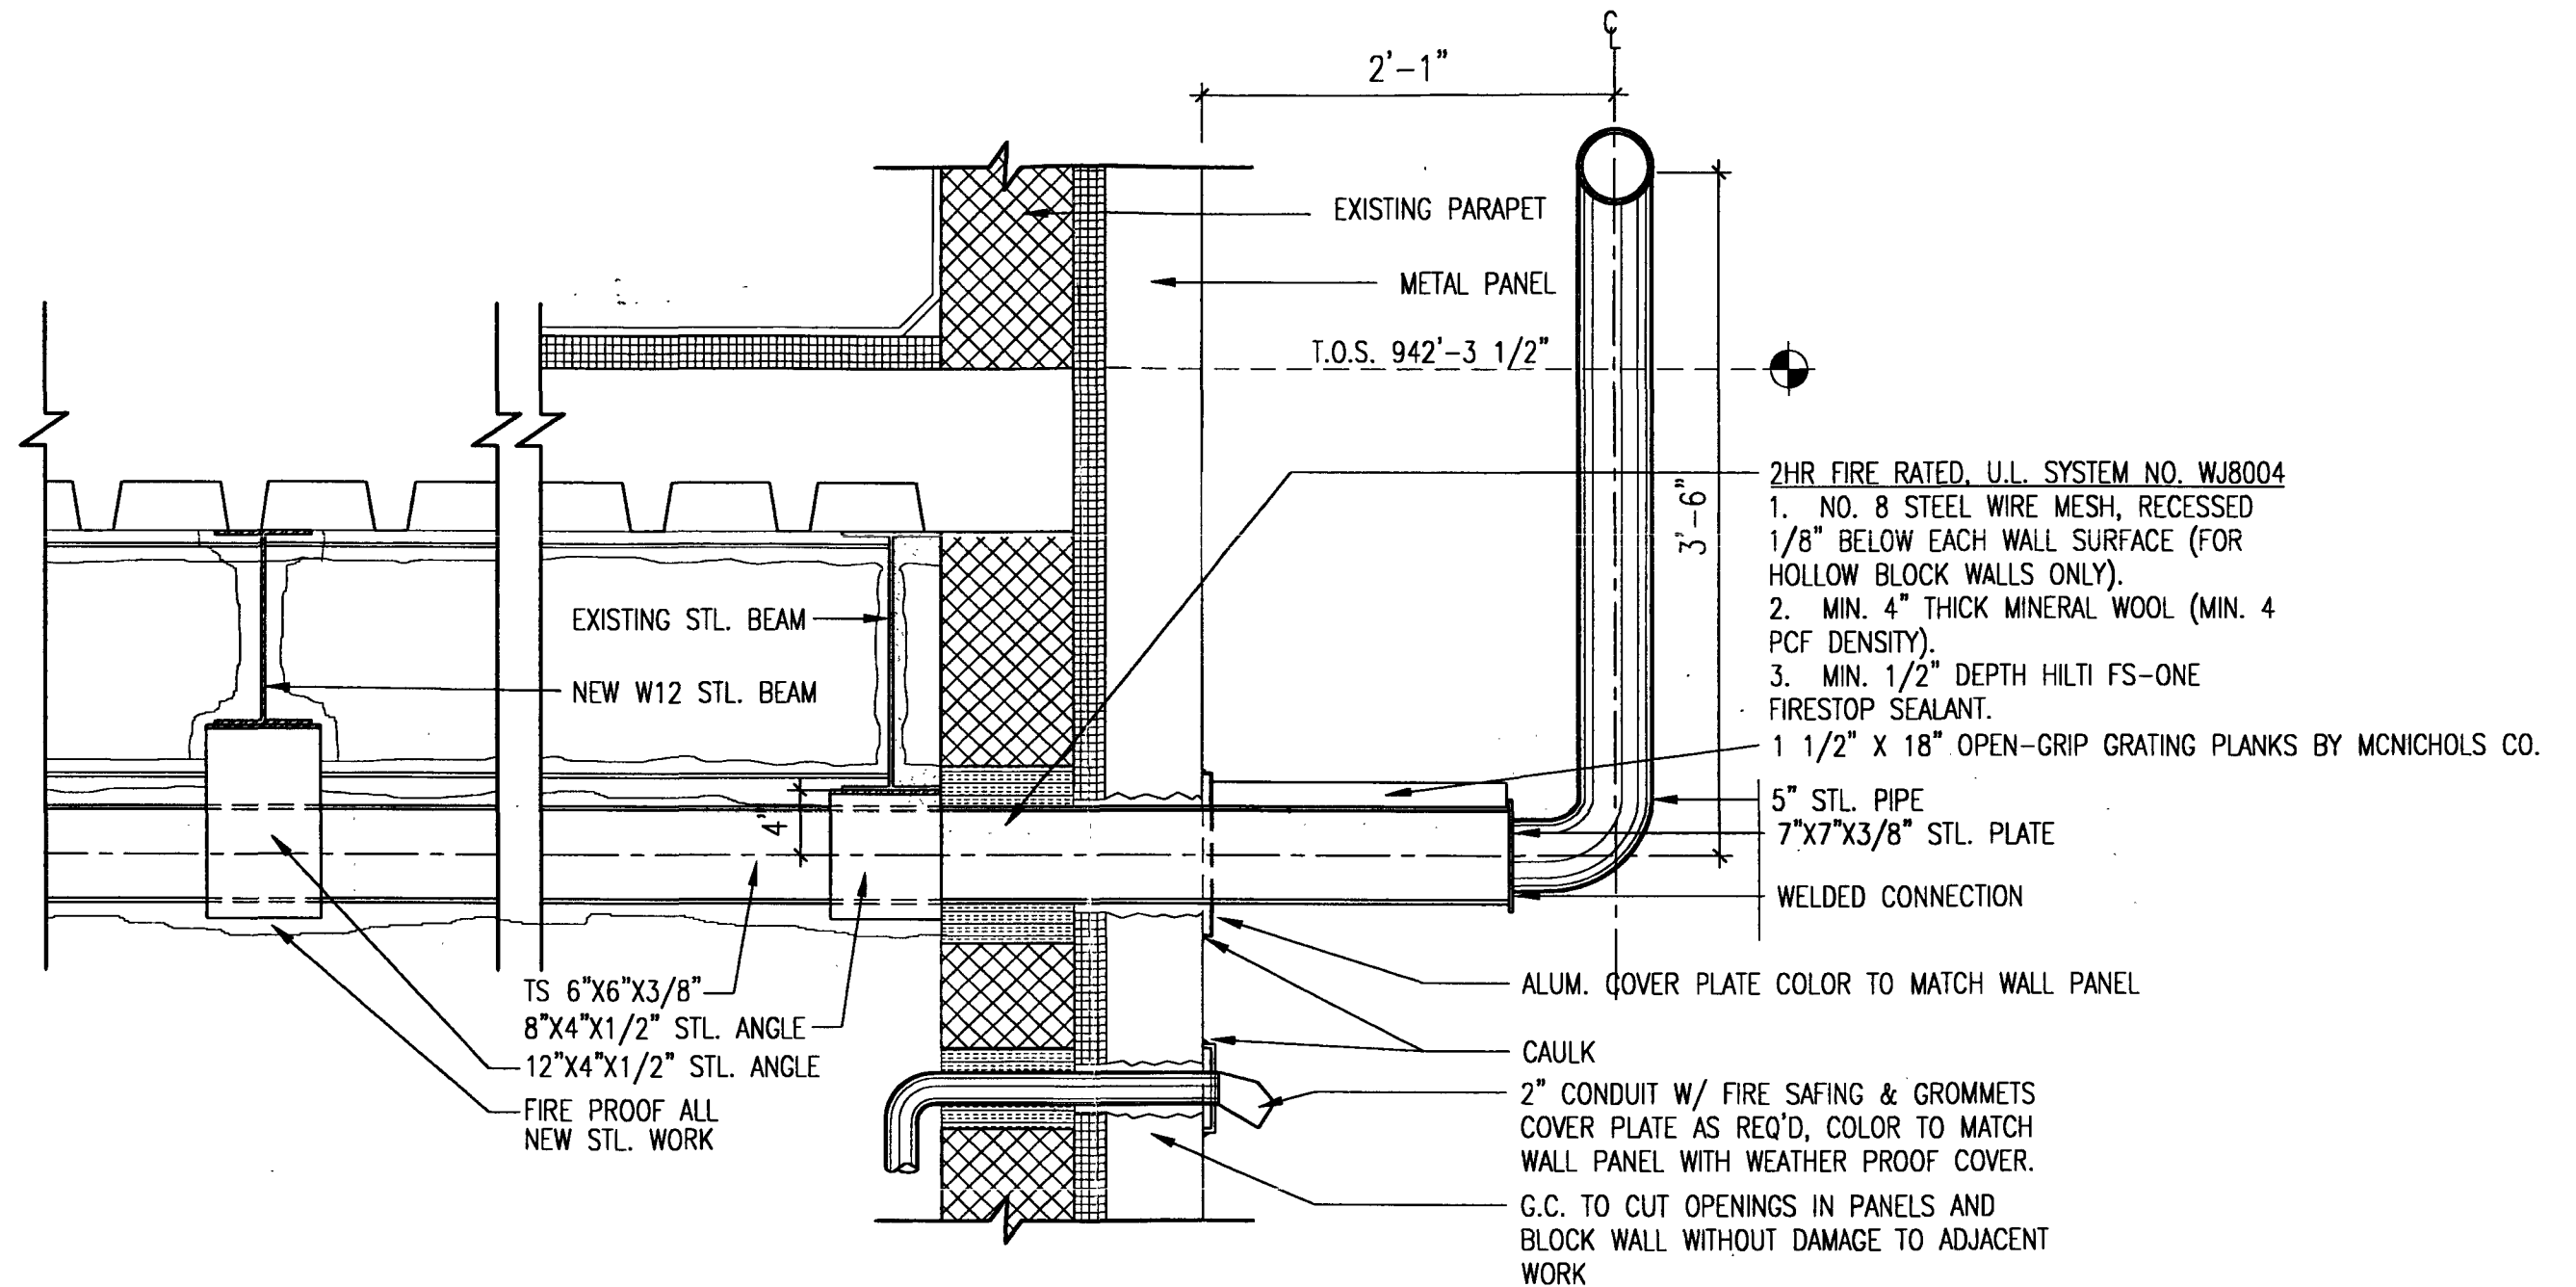

NOTES:

- 1) PROVIDE FIRE SAFING @ NEW 2" CONDUIT PENETRATIONS AS REQUIRED BY INSTALLATION
- 2) MICRO WAVE DISH SUPPORTS PROVIDED BY VENDOR
- 3) SEE STRUCTURAL SKETCH FOR WELDING INFORMATION
- 4) G.C. TO COORDINATE 6"x6" STEEL TUBE SUPPORT WITH EXISTING LIGHT FIXTURE.

No. Date Revisions

1. 11/9/98 ADDED GRATING & RAISED PIPE

Job Title/Drawing Title

MAYORS OFFICE OF EMERGENCY MANAGEMENT

PIPE WALL SUPPORT @ DISHES

Swanke Hayden Connell Ltd
295 Lafayette St., New York, New York 10012
212 228 9696, Fax 212 219 0059

Scale

N.T.S.

Drawn By

FSK-27

Issued

10/21/98

Job No.

5576A

© 1995 Swanke Hayden Connell Architects