

BRANKA MAYNIE CORNELL ARCHITECTS


Swank Hayden Connell Ltd
206 Lafayette St. New York, New York 10012

Shirley Properties, Inc.
 81 York Avenue, 27, NY 10018
 (212) 697-1000
 Franklyn, Inc.
 200 Lexington Ave., 27, NY 10018
 (212) 697-1000
 Chemical Associates, Ltd.
 200 Lexington Ave., 27, NY 10018
 (212) 697-1000
 The Chemical Bank, 27, NY 10018
 (212) 697-1000
 The Chemical Bank, 27, NY 10018
 (212) 697-1000
 The Chemical Bank, 27, NY 10018
 (212) 697-1000

DAFTUSER SCHEDULE			
WEEK	PATTERNS	BLACK-OUT	WALK-OUT
0 0 0	4 WAY	NOISE	340
0 0 0	4 WAY	1	350
0 0 0	4 WAY	2	170
0 0 0	4 WAY	3	00
0 0 0	3 WAY	NOISE	340
0 0 0	2 WAY	NOISE	340
0 0 0	1 WAY	NOISE	340
12 12 12	ALL PATT	NOISE	000

RETURN REGISTER SCHEDULE		
SIZE	QUOTED MAIL GPM	HIGH QUOTED MAIL GPM
10 x 14	275	100
10 x 25	575	300
20 x 22	1600	700

BRANCH DUCT SIZE SCHEDULE	DUCT SIZE	MAXIMUM CFS
	14 x 6	200
	14 x 8	400
	18 x 6	400
	18 x 8	500

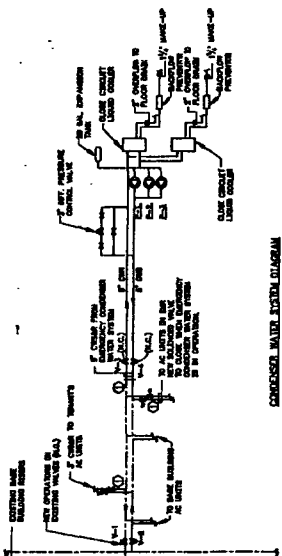

IMPROVING WATER SYSTEM DIAGRAM


NOTE: ALL NEW BUTTERFLY VALVES SHALL BE

VENTILATION INDEX						
ROOM NO.	SQUARE FEET	NO. OF PEOPLE	CUBIC FEET	INDEX OUTSIDE AIR SUPPLIED	PERCENT AIR SUPPLIED	TOTAL AIR EXHAUSTED
22-41	400	4	8000	2000	50	440
22-42	400	4	8000	2000	50	440
22-43	400	4	8000	2000	50	440
22-100	400	4	8000	2000	50	440

[illegible][illegible]

WAVE TWO	NUMBER OPERATION	EXCESSIVE OPERATION
4-1	0	0
4-2	0	0
4-3	0	0
4-4	0	0

THEORY OF THE MIND

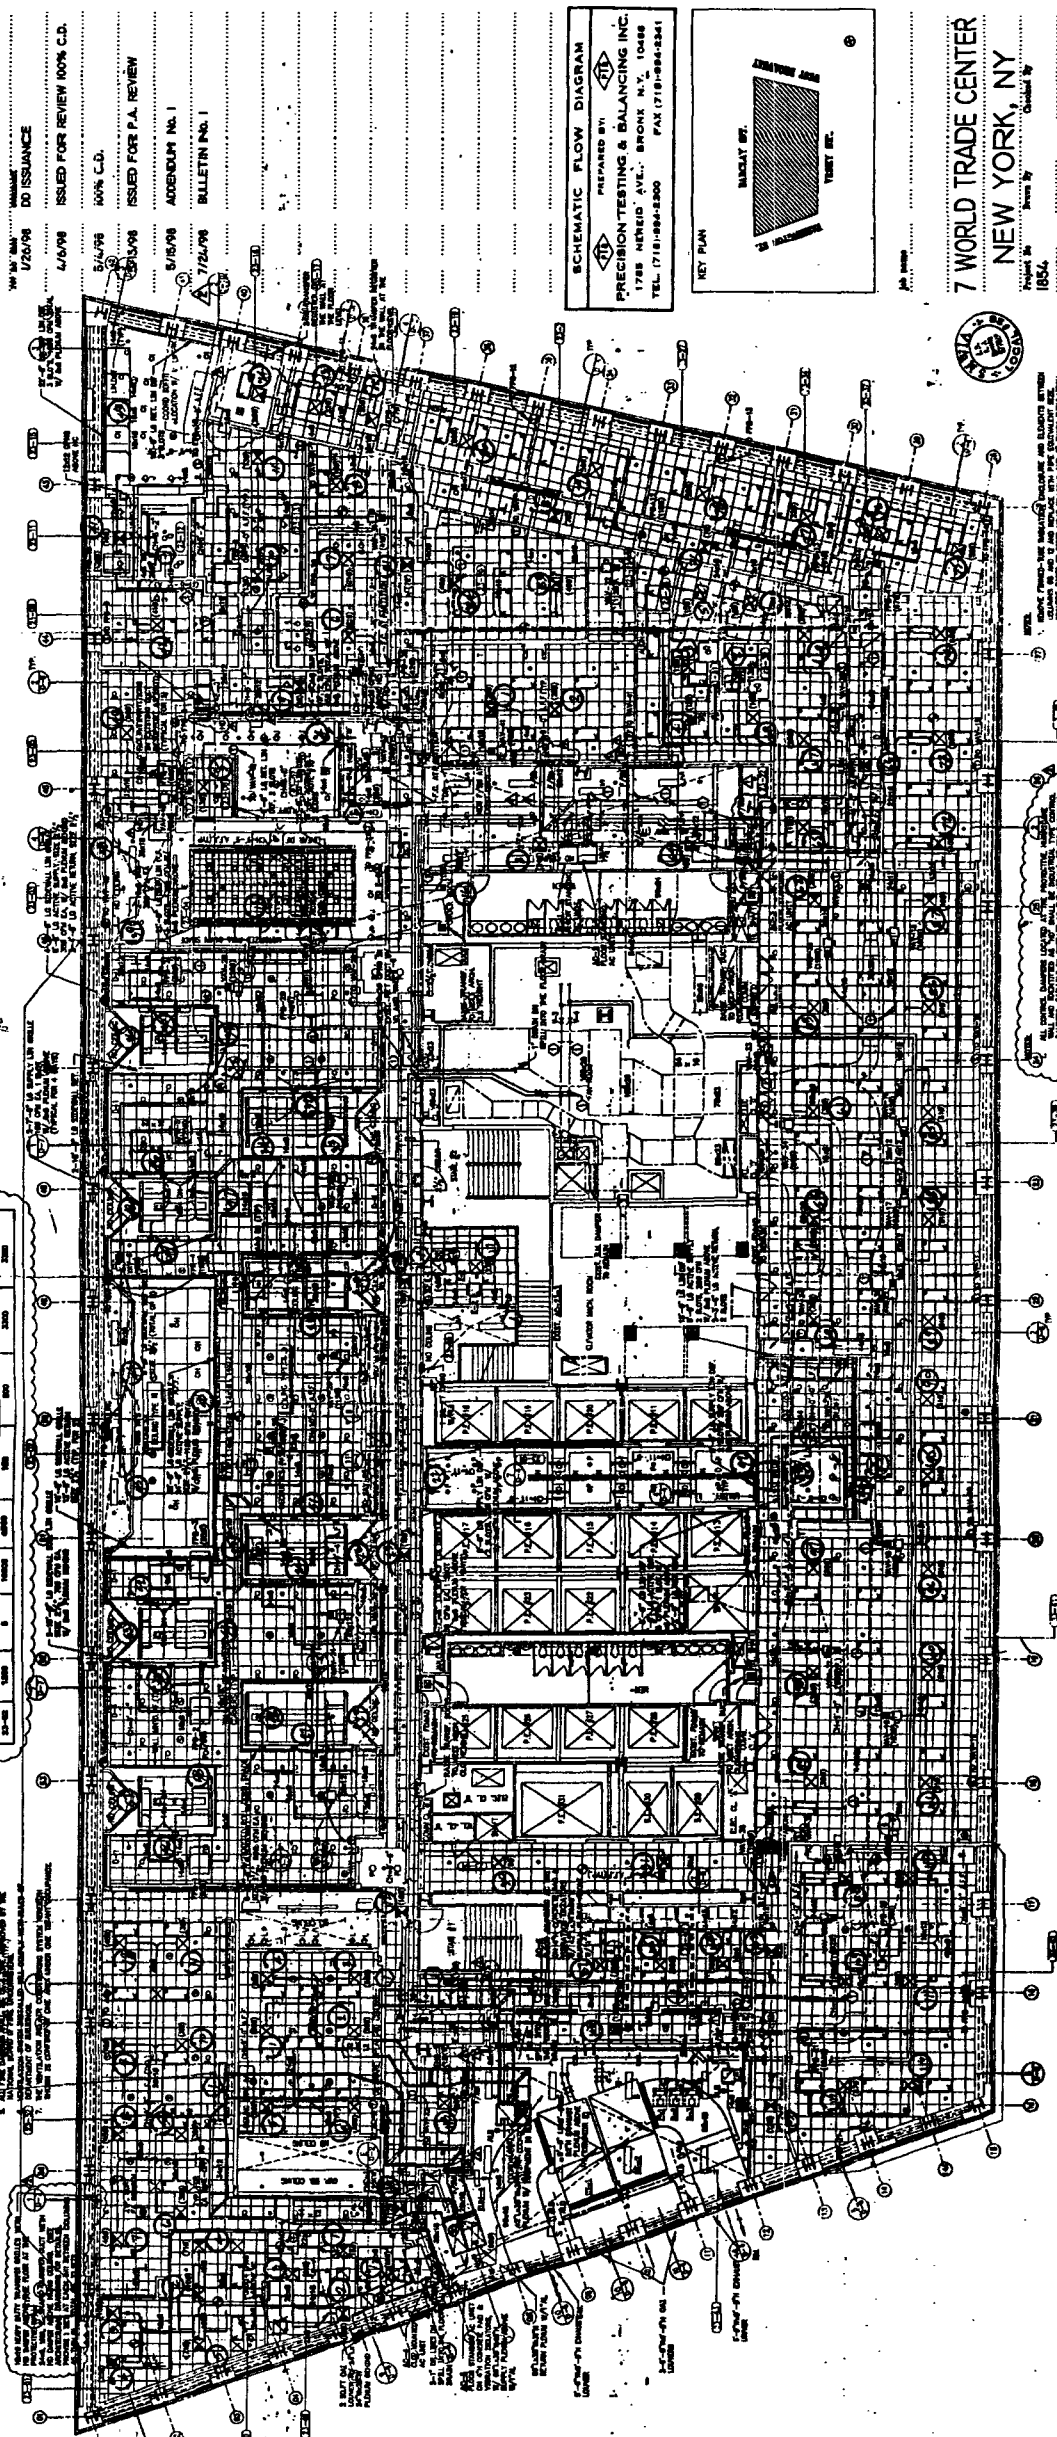[illegible][illegible]

THIS PLAN IS APPROVED ONLY FOR WORK INDICATED ON THE APPLICATION.
SPECIFIC: ON SHEET. ALL OTHER MATTERS BEING AND NOT TO BE HELD UPON OR
TO BE SUBMITTED AS OTHER WORK APPROVED OR IN ACCORDANCE WITH APPLICABLE

SCHEMATIC FLOW DIAGRAM

 PREPARED BY: 

PRECISION TESTING & BALANCING INC.
1788 MERRID AVENUE, BRONX N.Y. 10466
TEL. (718)-884-2300 FAX (718)-884-2341

7 WORLD TRADE CENTER
NEW YORK, NY

23RD FLOOR HVAC PLAN

0-12-8/1

Drawing No. **ML23**